
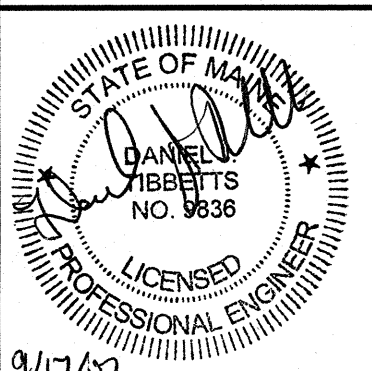


NOTE:

1. SEE SHEET E-001 FOR LEGEND AND GENERAL NOTES.

KEYED NOTE:

① PROVIDE POWER FOR HVAC CONTROLS. FIELD COORDINATE EXACT LOCATION OF ELECTRICAL CONNECTION.

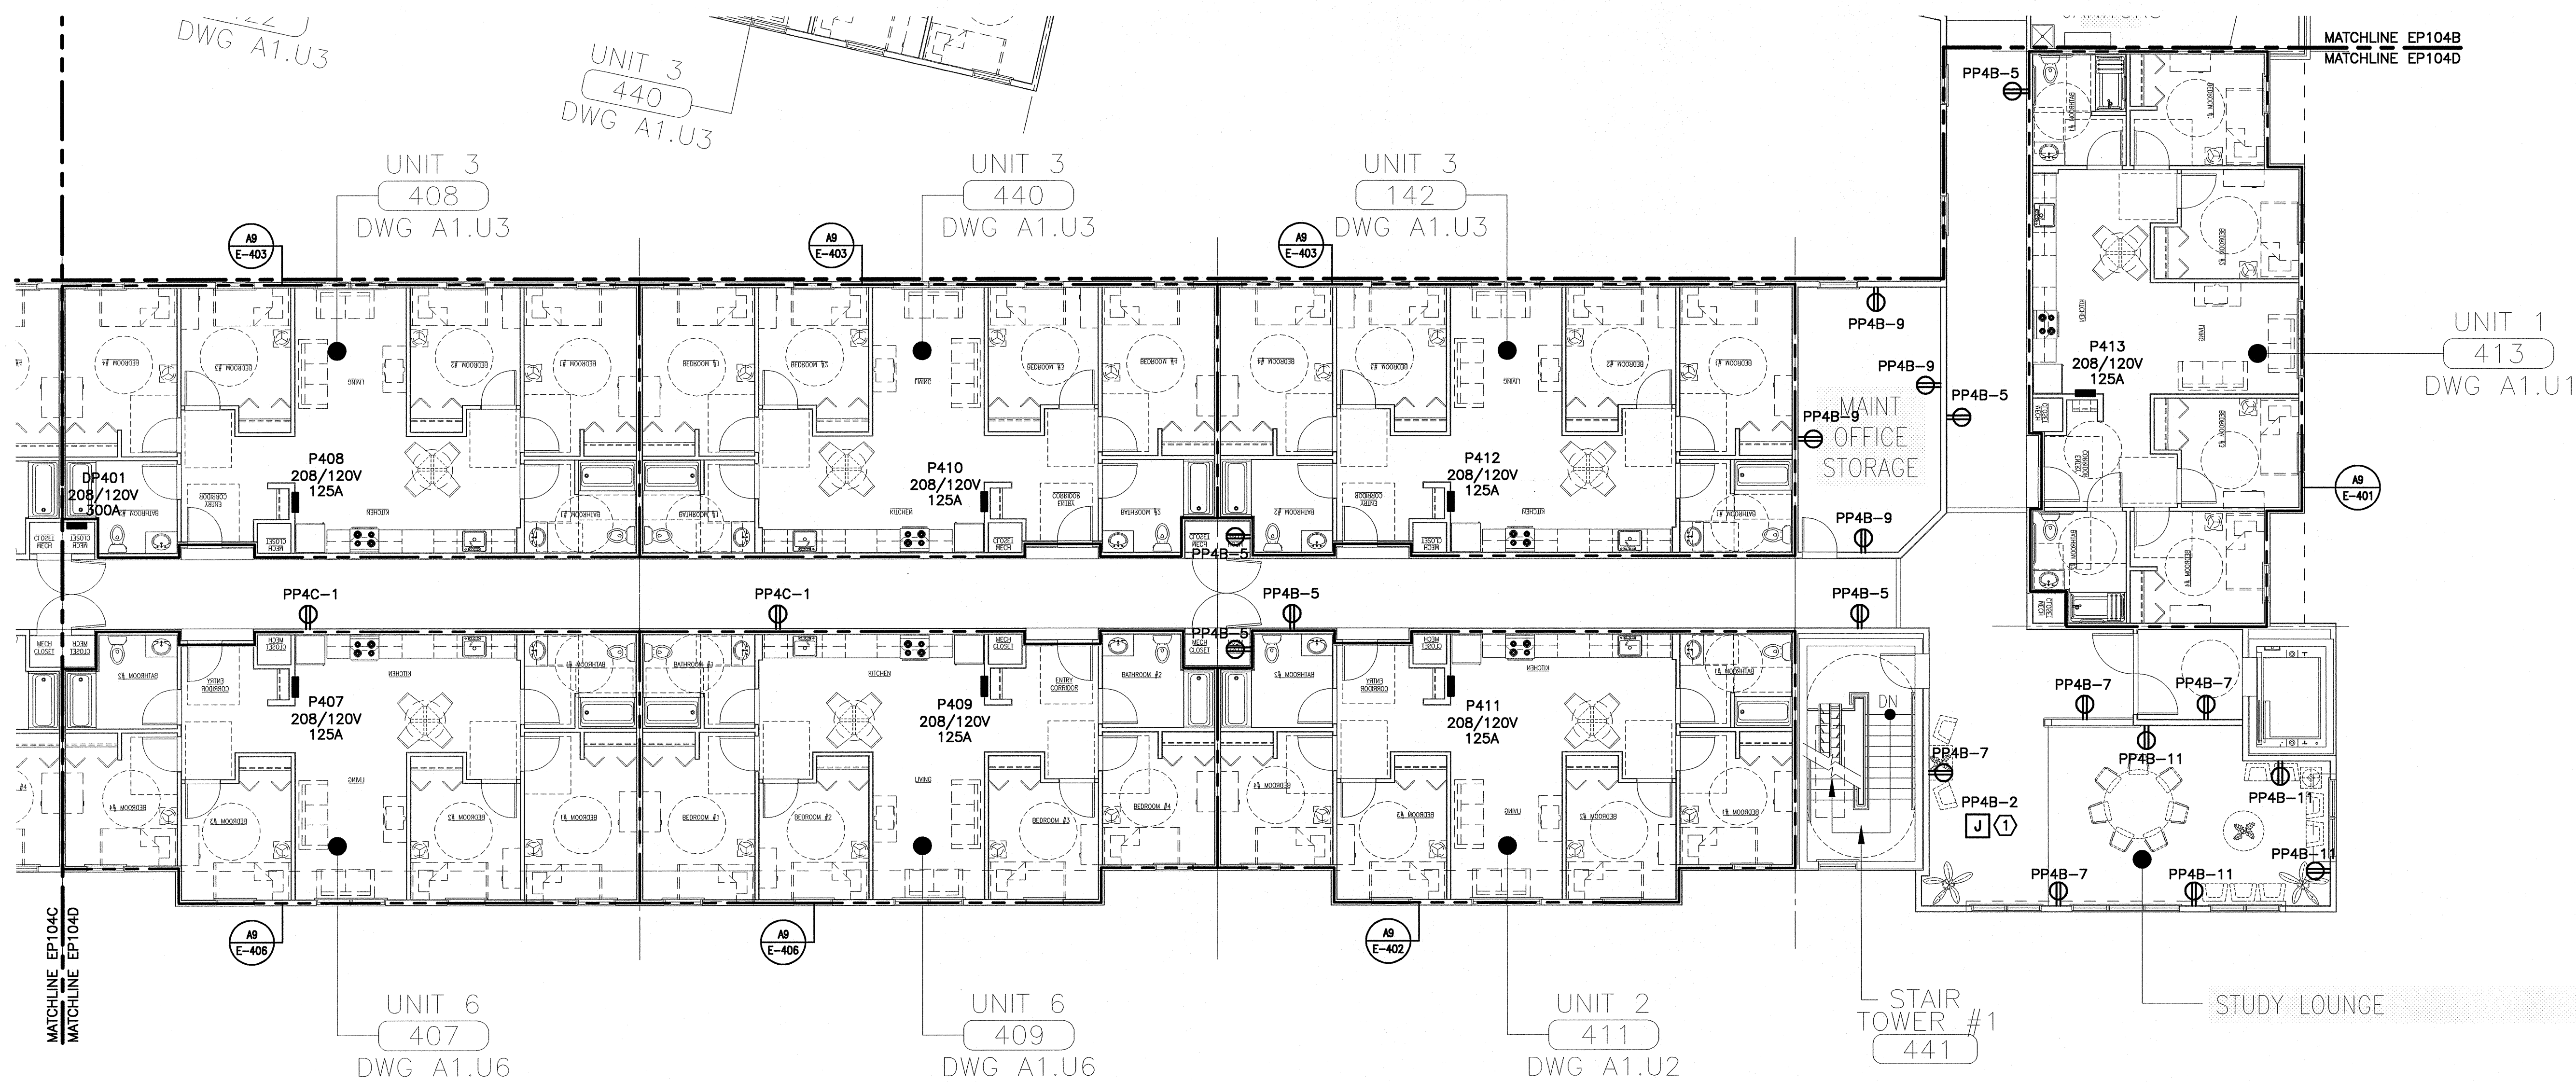

PROJECT TITLE:
**BAYSIDE VILLAGE
 STUDENT HOUSING COMPLEX**
 PORTLAND, ME

CURRENT ISSUE STATUS:
**ISSUED FOR CONSTRUCTION
 9-14-07**

REV	DESCRIPTION	DATE
0	ISSUED FOR CONSTRUCTION	9-14-07

GRAPHIC SCALE:
 0" 1"

SCALE: 1/8"=1'-0"
 PROJECT MANAGER: DJT
 JC/DRAWN BY: CDS
 A/E OF RECORD: DJT
 CAD FILE: EP104D-0712S
 PROJECT NO: 0712S
 DATE: 9-14-07

SHEET TITLE:
**FOURTH FLOOR
 POWER PLAN D**

SHEET No.
EP104D

A1 **FOURTH FLOOR PLAN**

1/8"=1'-0"