


**NOTE:**

1. SEE SHEET E-001 FOR LEGEND AND GENERAL NOTES.
2. ALL STARTERS, DISCONNECTS, CONVENIENCE OUTLETS AND DUCT DETECTORS ARE FURNISHED WITH MECHANICAL EQUIPMENT.


**ESB**  
**E.S. BOULOS CO**  
 ELECTRICAL CONTRACTORS

45 BRADLEY DRIVE  
 WESTBROOK, ME 04092  
 TEL: (207) 464-3706  
 FAX: (207) 464-1833

ARCHITECTURE ENGINEERING PLANNING  
 SMART  
 144 Fore Street/P.O. Box 618  
 Portland, Maine 04104  
 tel. (207) 772-3846  
 fax. (207) 772-1070

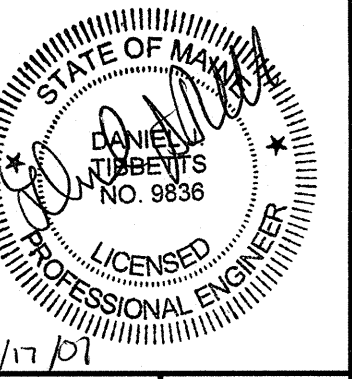

9/17/07

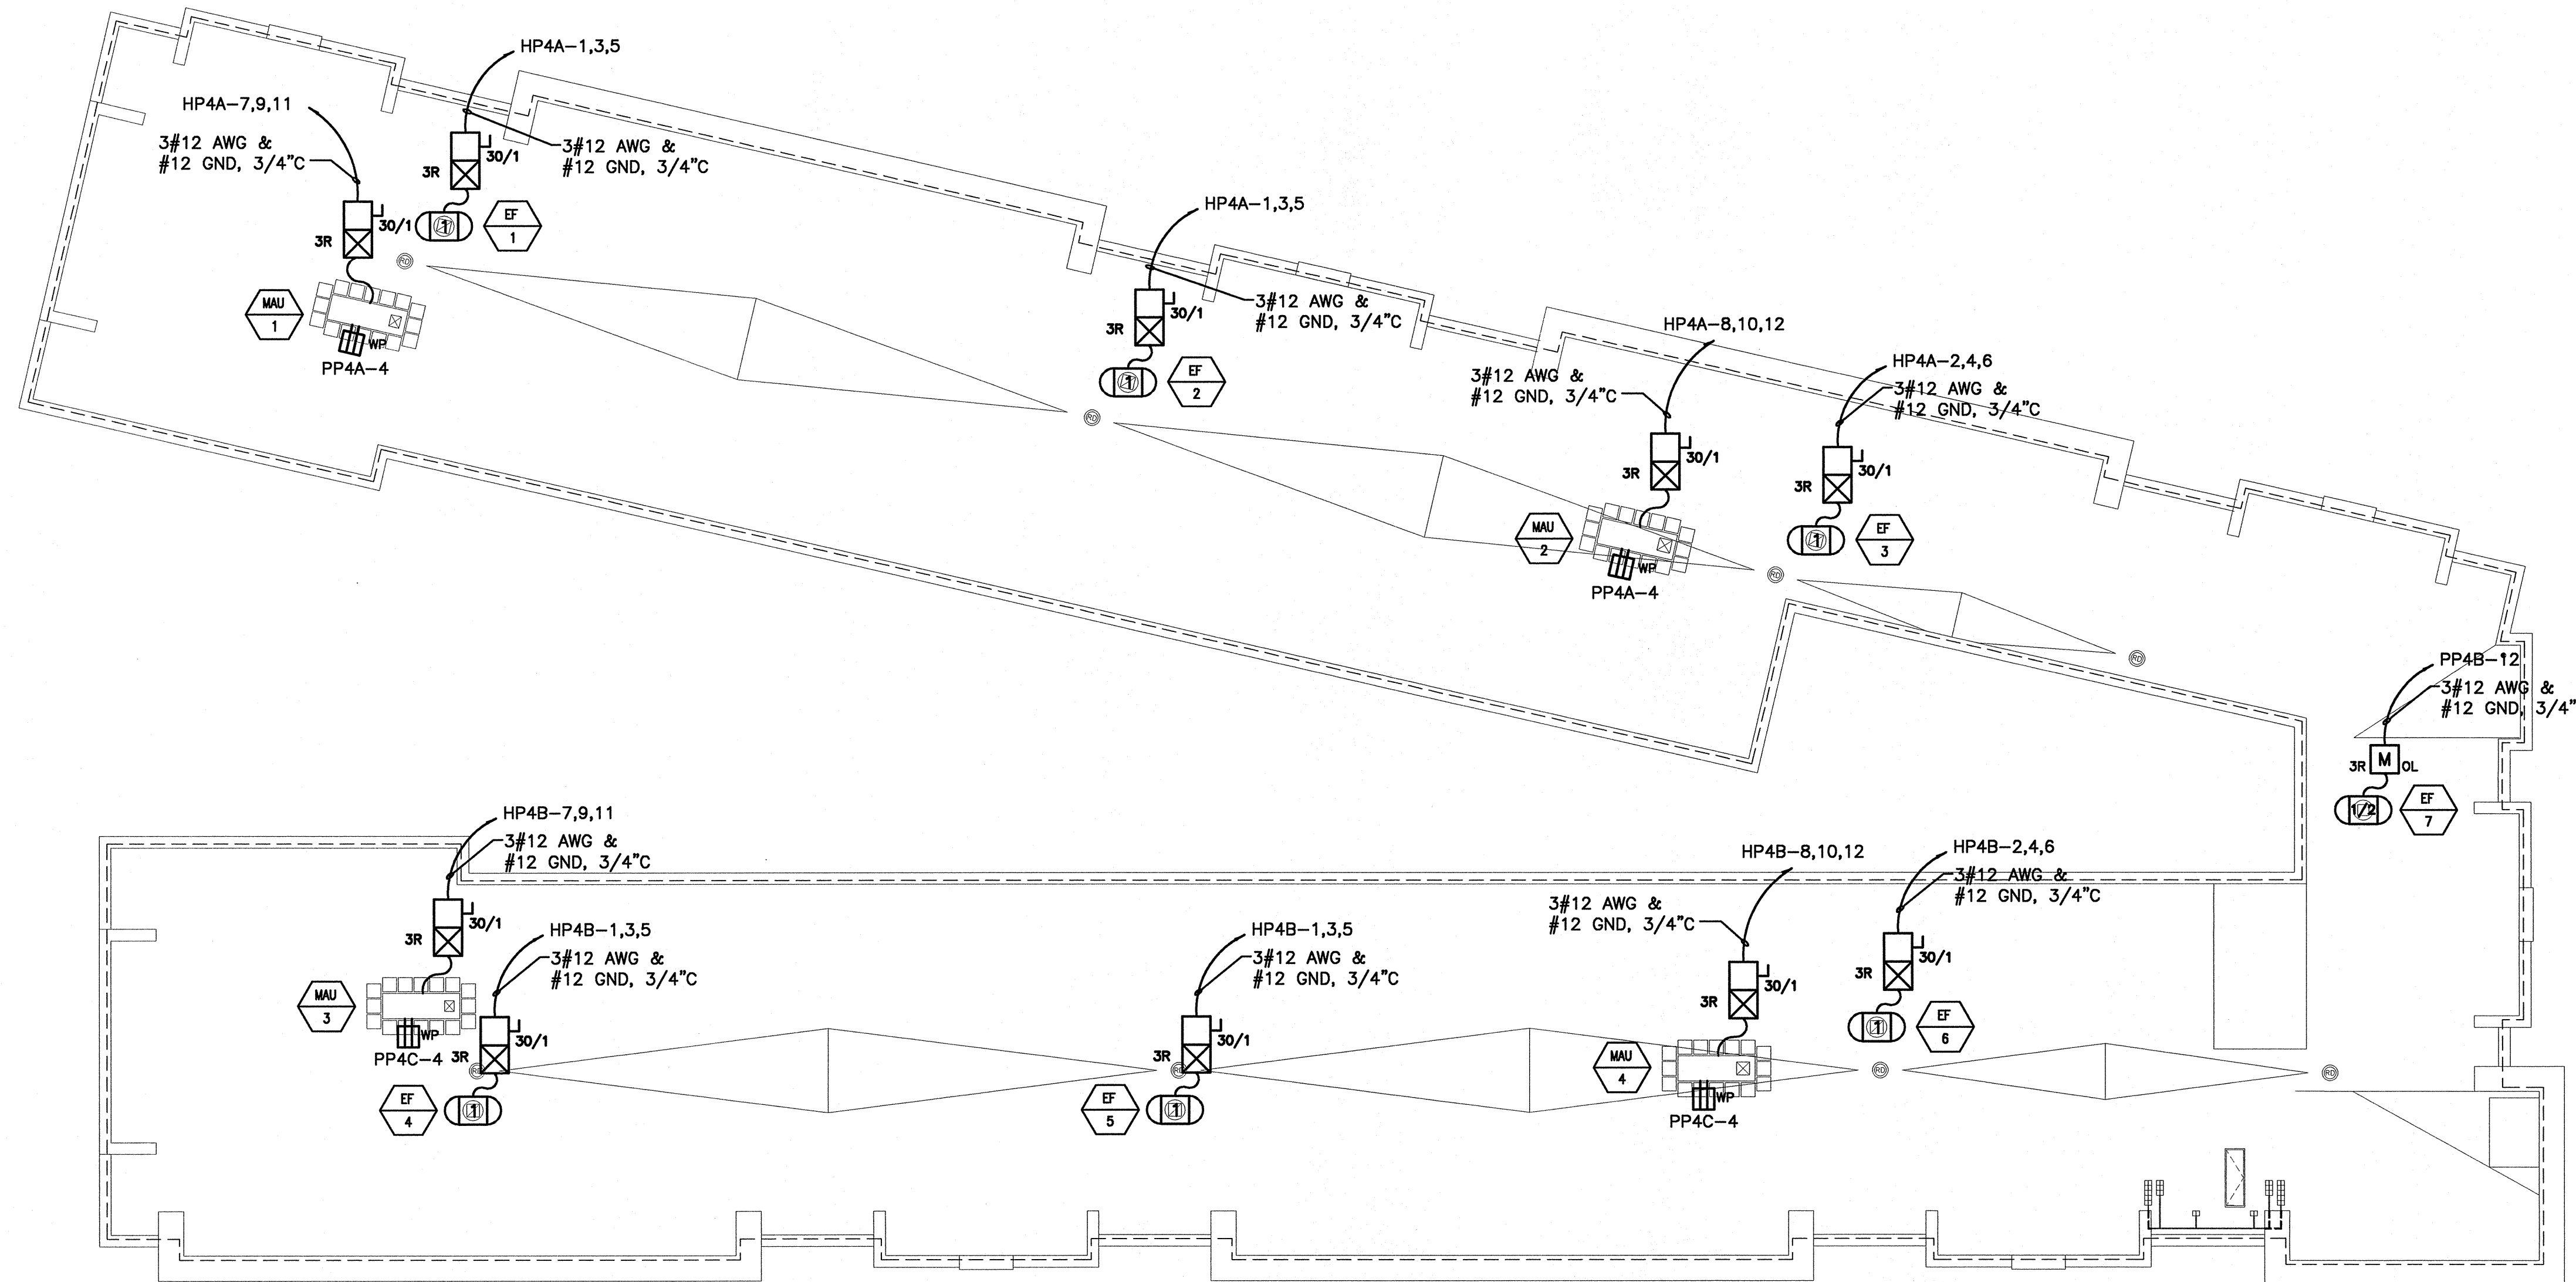

PROJECT TITLE:  
**BAYSIDE VILLAGE  
 STUDENT HOUSING COMPLEX**  
 PORTLAND, ME

CURRENT ISSUE STATUS:  
**ISSUED FOR CONSTRUCTION  
 9-14-07**

REV	DESCRIPTION	DATE
0	ISSUED FOR CONSTRUCTION	9-14-07

GRAPHIC SCALE:  
 0" 1"

SCALE: 1/16"=1'-0"  
 PROJECT MANAGER: DJT  
 JC/DRAWN BY: CDS  
 A/E OF RECORD: DJT  
 CAD FILE: EP105-07125  
 PROJECT NO: 07125  
 DATE: 9-14-07

SHEET TITLE:  
**ROOF  
 POWER PLAN**

SHEET No.  
**EP105**

A1 ROOF PLAN

1/16"=1'-0"