

**NOTE:**

1. SEE SHEET E-001 FOR LEGEND AND GENERAL NOTES.


**ESB**  
**E.S. BOULOS CO**  
 ELECTRICAL CONTRACTORS

45 BRADLEY DRIVE  
 WESTBROOK, ME 04092  
 TEL: (207) 464-3706  
 FAX: (207) 464-1833

**SM**  
**RT**

ARCHITECTURE ENGINEERING PLANNING

SMRT  
 144 Fore Street/P.O. Box 618  
 Portland, Maine 04104  
 tel. (207) 772-3846  
 fax. (207) 772-1070

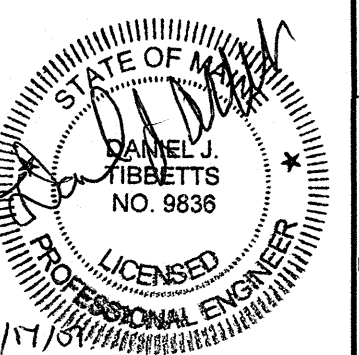

PROJECT TITLE:  
**BAYSIDE VILLAGE  
 STUDENT HOUSING COMPLEX**  
 PORTLAND, ME

CURRENT ISSUE STATUS:  
**ISSUED FOR CONSTRUCTION  
 9-14-07**


REV	DESCRIPTION	DATE
0	ISSUED FOR CONSTRUCTION	9-14-07

REV	DESCRIPTION	DATE
0	ISSUED FOR CONSTRUCTION	9-14-07

GRAPHIC SCALE:  
 0" 1"  
 SCALE: 1/8"=1'-0"  
 PROJECT MANAGER: DJT  
 JC/DRAWN BY: CDS  
 A/E OF RECORD: DJT  
 CAD FILE: EY101C-07125  
 PROJECT NO: 07125  
 DATE: 9-14-07

SHEET TITLE:  
**FIRST FLOOR  
 SYSTEMS PLAN C**

SHEET No.  
**EY101C**

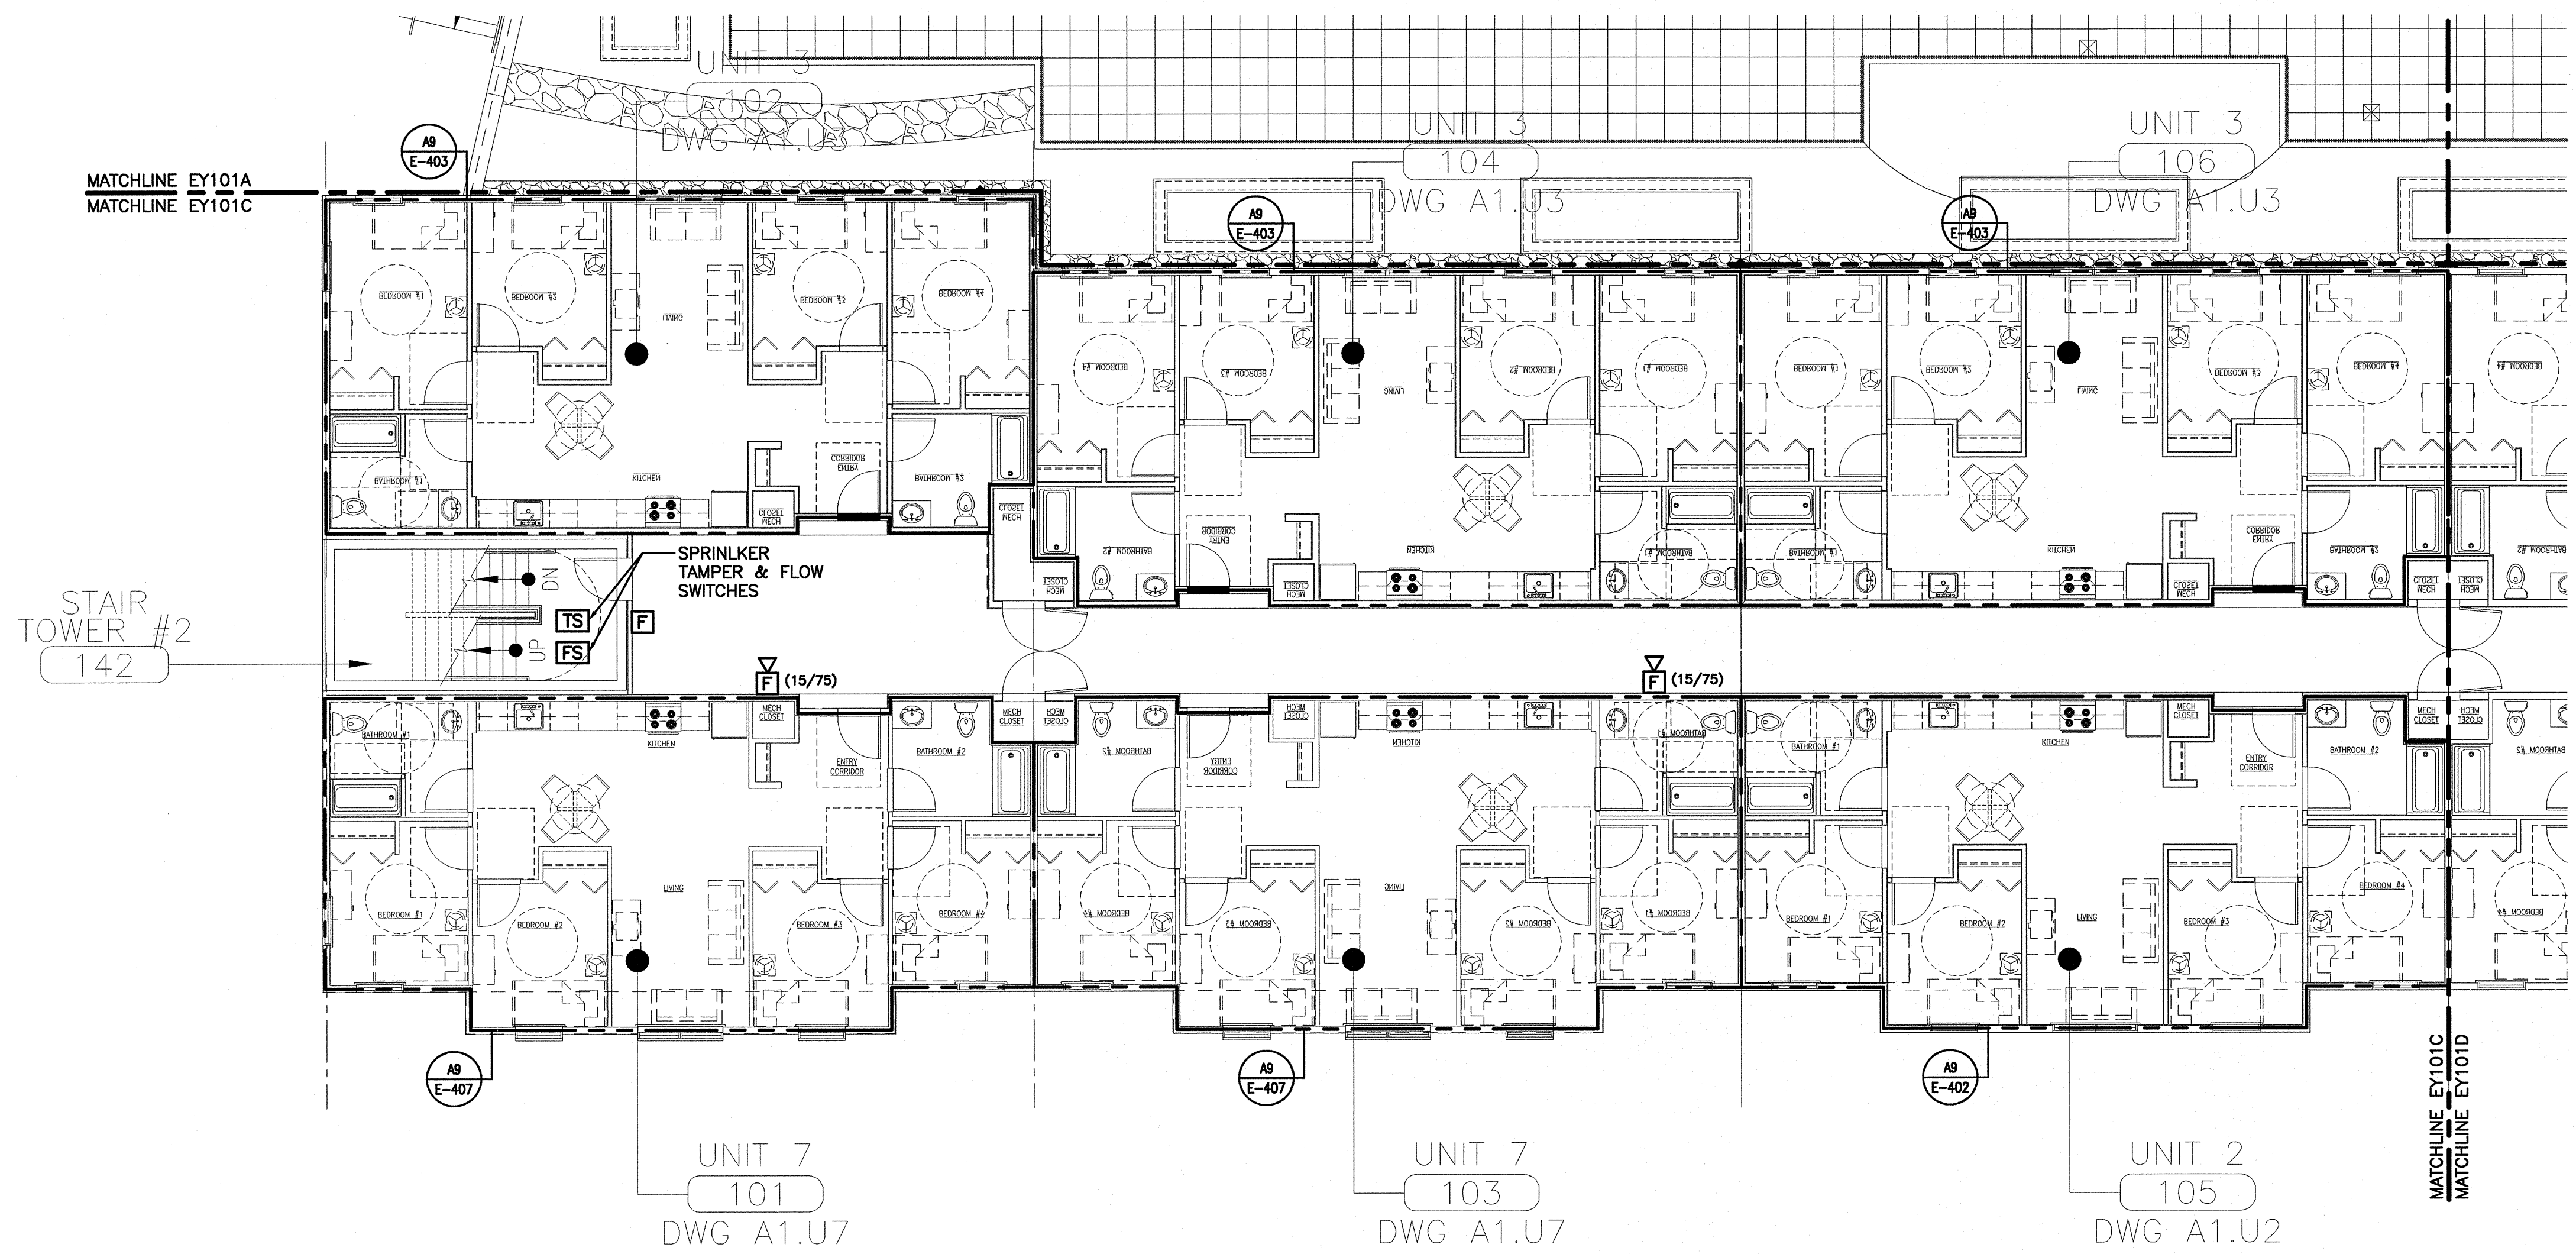

**A1** FIRST FLOOR PLAN  
 1/8"=1'-0"