

**NOTE:**

1. SEE SHEET E-001 FOR LEGEND AND GENERAL NOTES.


**ESB**  
**E.S. BOULOS CO**  
 ELECTRICAL CONTRACTORS

45 BRADLEY DRIVE  
 WESTBROOK, ME 04092  
 TEL: (207) 464-3706  
 FAX: (207) 464-1833

**SM**  
**RT**

ARCHITECTURE ENGINEERING PLANNING  
 SMART

144 Fore Street/P.O. Box 618  
 Portland, Maine 04104  
 tel. (207) 772-3846  
 fax. (207) 772-1070

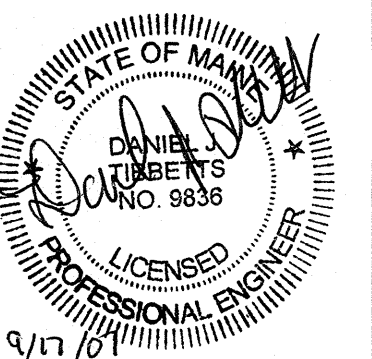

**BAYSIDE VILLAGE**  
**STUDENT HOUSING COMPLEX**  
 PORTLAND, ME

**ISSUED FOR CONSTRUCTION**  
 9-14-07

PROJECT TITLE  
 CURRENT ISSUE STATUS


REV	DESCRIPTION	DATE
0	ISSUED FOR CONSTRUCTION	9-14-07

GRAPHIC SCALE:  
 0" 1"

SCALE: 1/8"=1'-0"  
 PROJECT MANAGER: DJT  
 JC/DRAWN BY: CDS  
 A/E OF RECORD: DJT  
 CAD FILE: EY101D-07125  
 PROJECT NO: 07125  
 DATE: 9-14-07

SHEET TITLE:  
**FIRST FLOOR SYSTEMS PLAN D**

SHEET No.  
**EY101D**  
© copyright 2007 SMART INC.

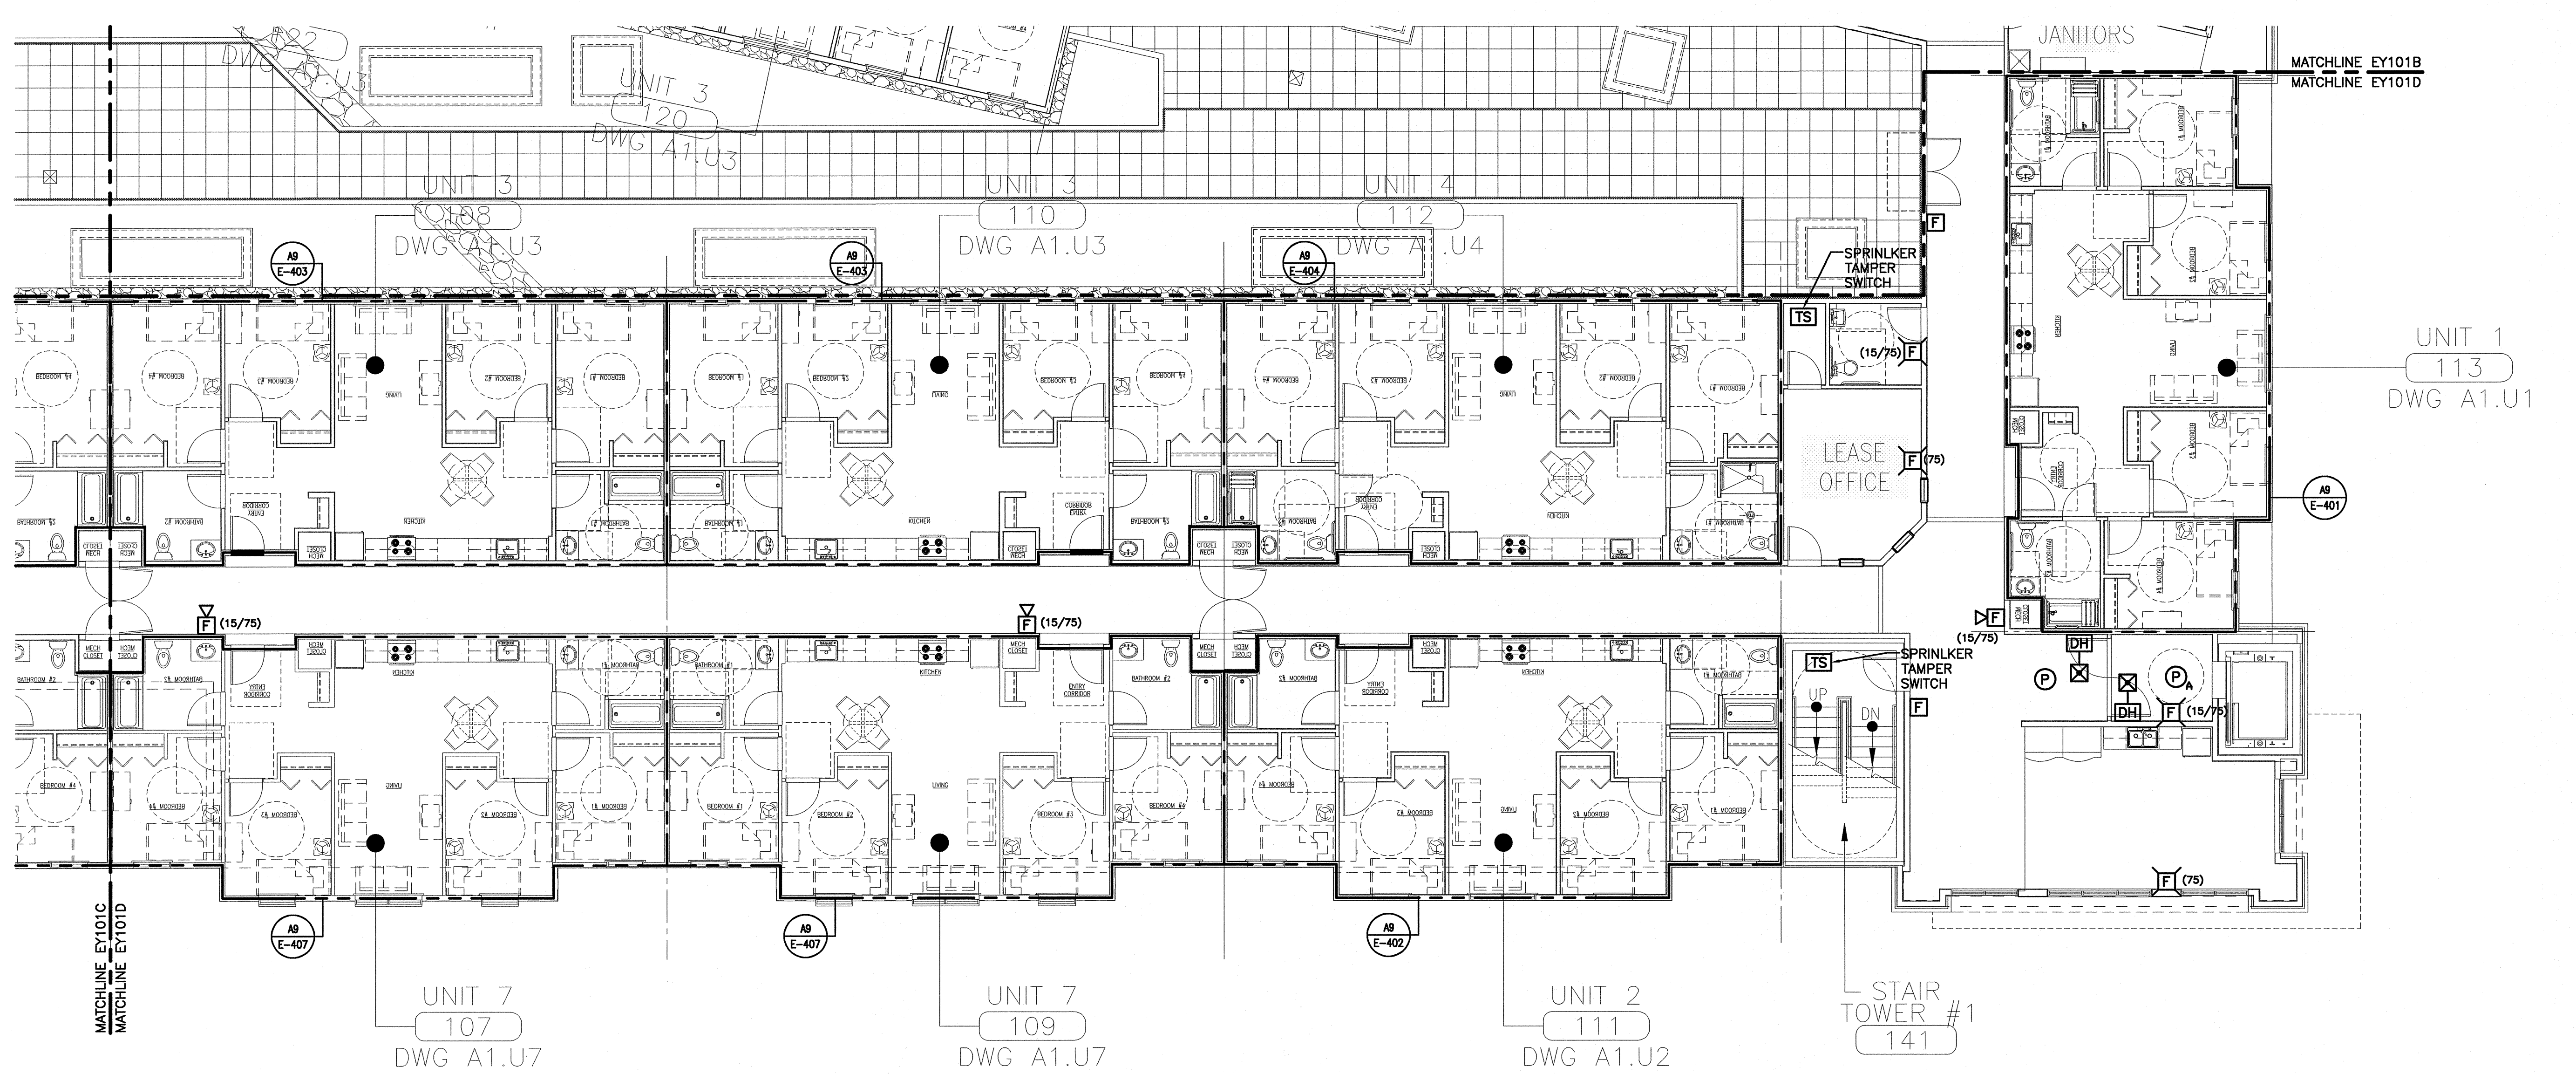

**A1** FIRST FLOOR PLAN  
 1/8"=1'-0"