

**NOTE:**


1. SEE SHEET E-001 FOR LEGEND AND GENERAL NOTES.

**ESB**  
**E.S. BOULOS CO**  
 ELECTRICAL CONTRACTORS

45 BRADLEY DRIVE  
 WESTBROOK, ME 04092  
 TEL: (207) 464-3706  
 FAX: (207) 464-1833

**SM**  
**RT**

ARCHITECTURE ENGINEERING PLANNING  
 SMART  
 144 Fore Street/P.O. Box 618  
 Portland, Maine 04104  
 tel. (207) 772-3846  
 fax. (207) 772-1070

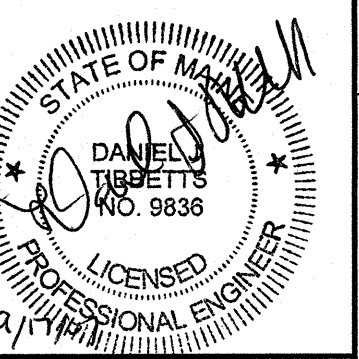

PROJECT TITLE:  
**BAYSIDE VILLAGE  
 STUDENT HOUSING COMPLEX**  
 PORTLAND, ME

CURRENT ISSUE STATUS:  
**ISSUED FOR CONSTRUCTION  
 9-14-07**

REV	DESCRIPTION	DATE
0	ISSUED FOR CONSTRUCTION	9-14-07

GRAPHIC SCALE:  
 0" 1"

SCALE: 1/8"=1'-0"

PROJECT MANAGER: DJT

JC/DRAWN BY: CDS

A/E OF RECORD: DJT

CAD FILE: EY102C-07125

PROJECT NO: 07125

DATE: 9-14-07


SHEET TITLE:

**SECOND FLOOR  
 SYSTEMS PLAN C**

SHEET No.

**EY102C**

© COPYRIGHT 2007 SMART INC.

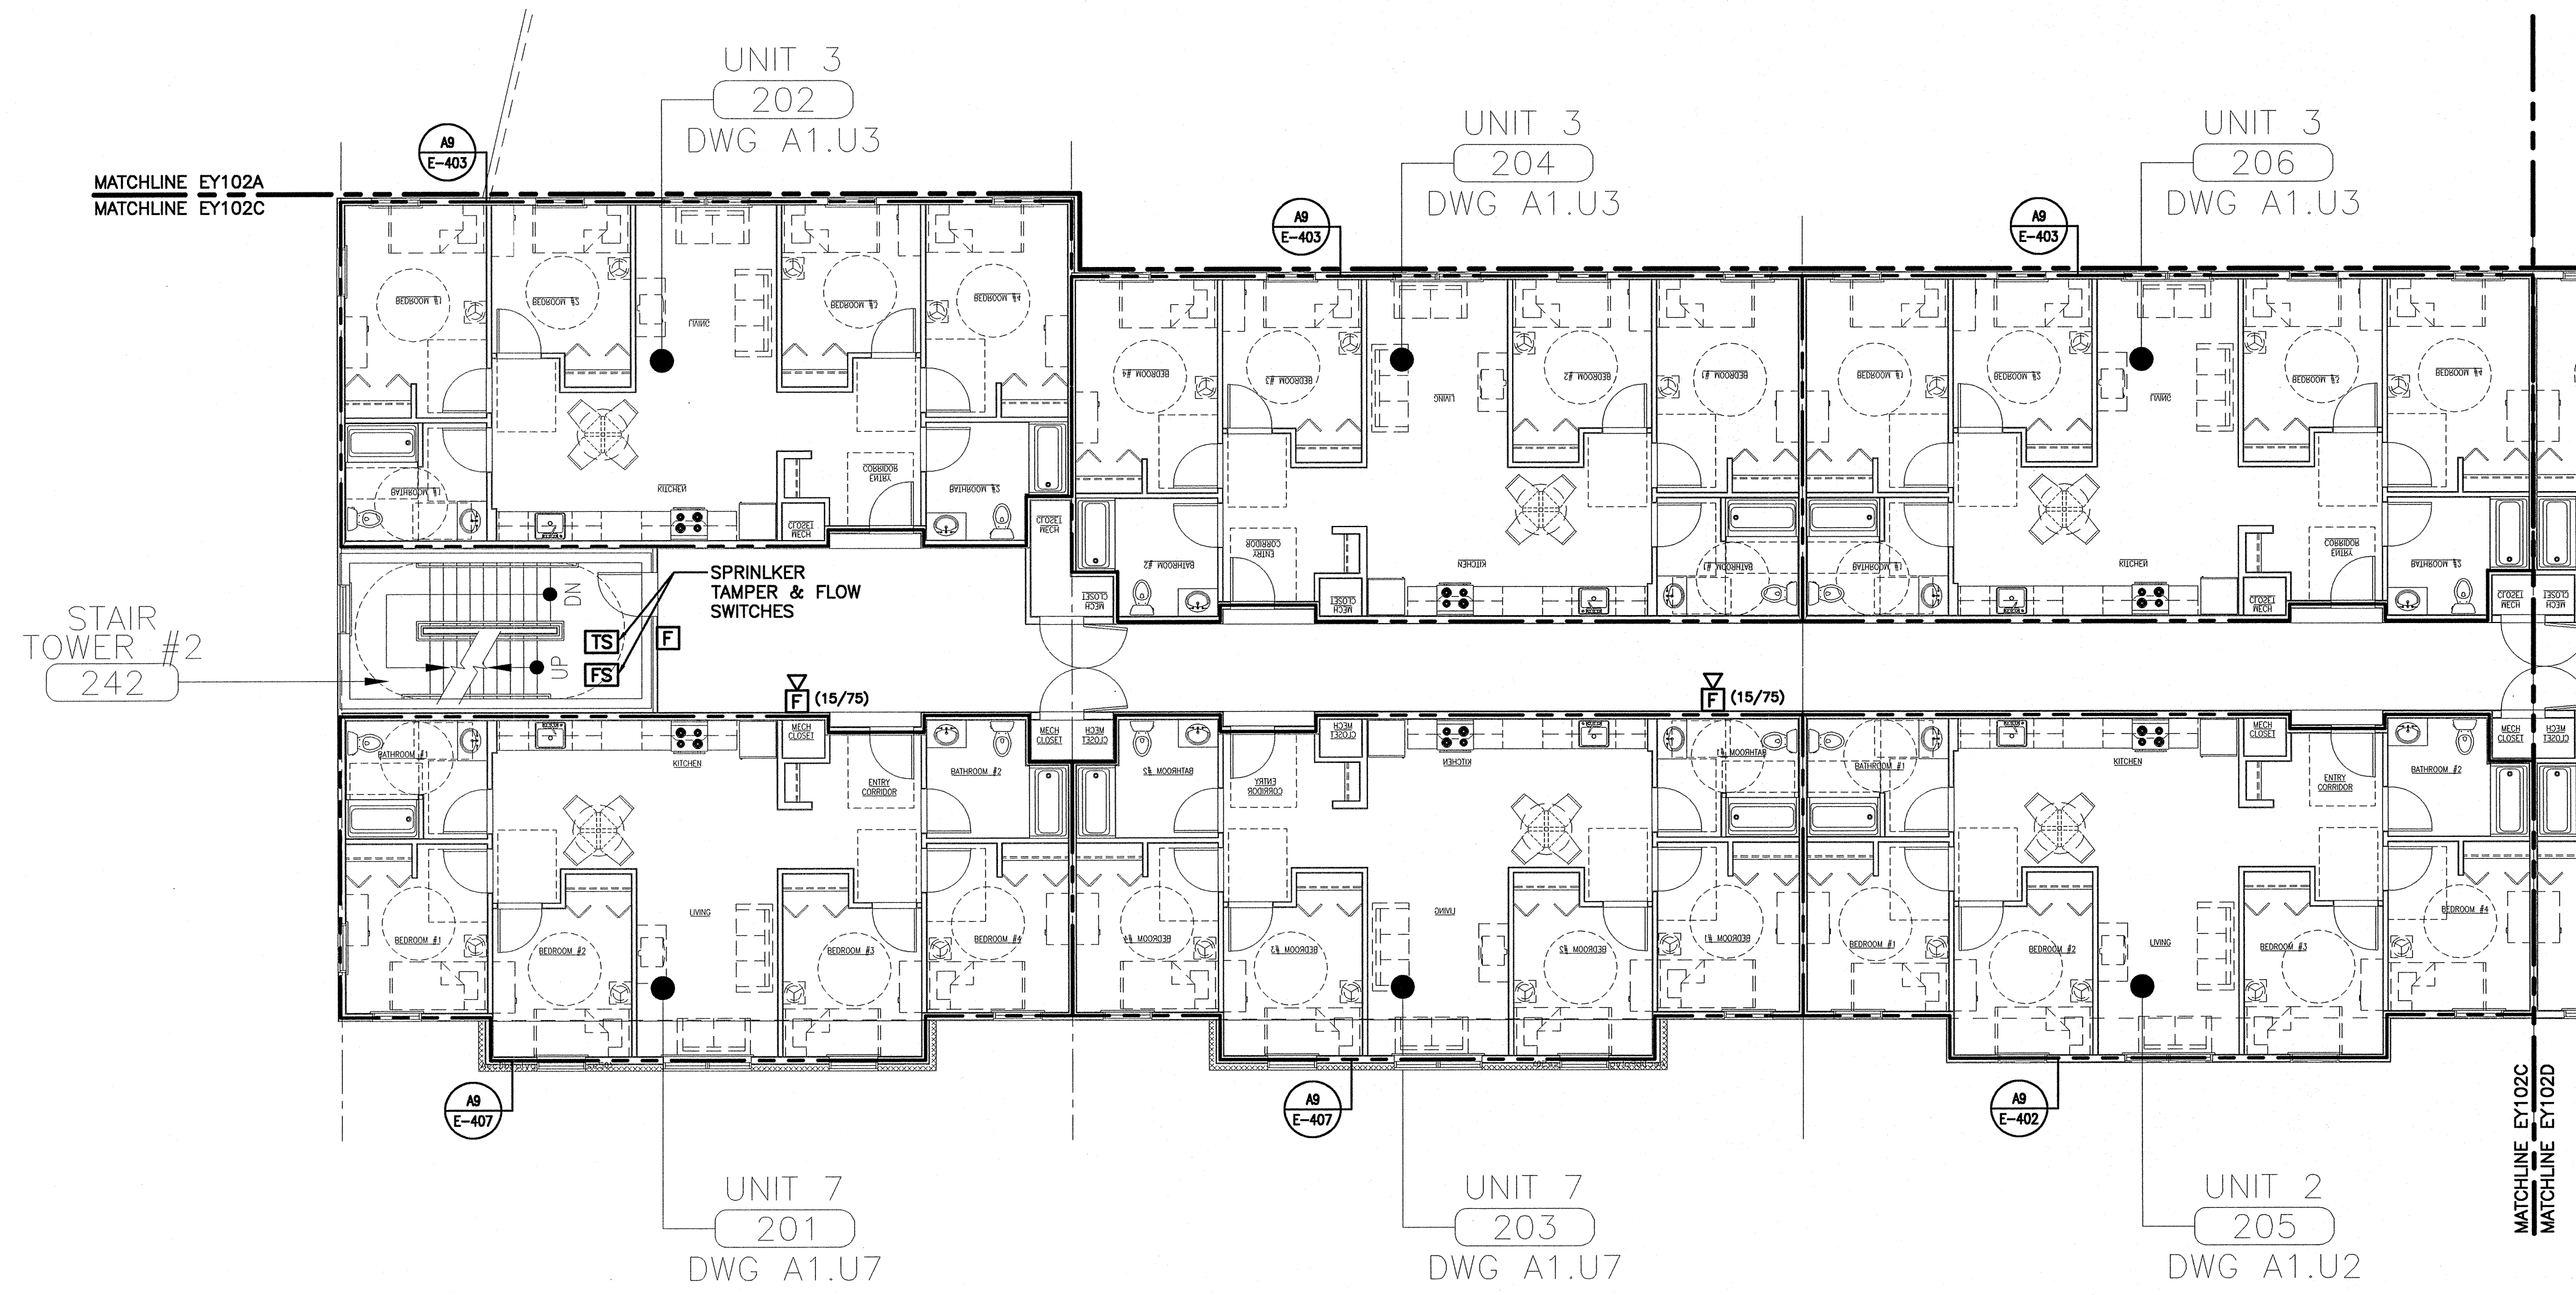

**A1 SECOND FLOOR PLAN**

1/8"=1'-0"