

NOTE:

1. SEE SHEET E-001 FOR LEGEND AND GENERAL NOTES.


ESB
E.S. BOULOS CO
 ELECTRICAL CONTRACTORS

45 BRADLEY DRIVE
 WESTBROOK, ME 04092
 TEL: (207) 464-3706
 FAX: (207) 464-1833

SM
RT

ARCHITECTURE ENGINEERING PLANNING

SMART
 144 Fore Street, P.O. Box 618
 Portland, Maine 04104
 tel. (207) 772-3846
 fax. (207) 772-1070

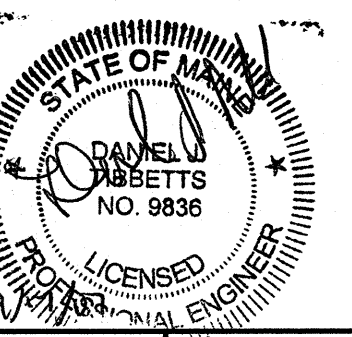

BAYSIDE VILLAGE
STUDENT HOUSING COMPLEX
 PORTLAND, ME

ISSUED FOR CONSTRUCTION
9-14-07

PROJECT TITLE

CURRENT ISSUE STATUS


REV	DESCRIPTION	DATE
0	ISSUED FOR CONSTRUCTION	9-14-07

GRAPHIC SCALE: 0" = 1"

SCALE: 1/8"=1'-0"
 PROJECT MANAGER: DJT
 JC/DRAWN BY: CDS
 A/E OF RECORD: DJT
 CAD FILE: EY103A-07125
 PROJECT NO: 07125
 DATE: 9-14-07

SHEET TITLE:
THIRD FLOOR SYSTEMS PLAN A

SHEET No.
EY103A

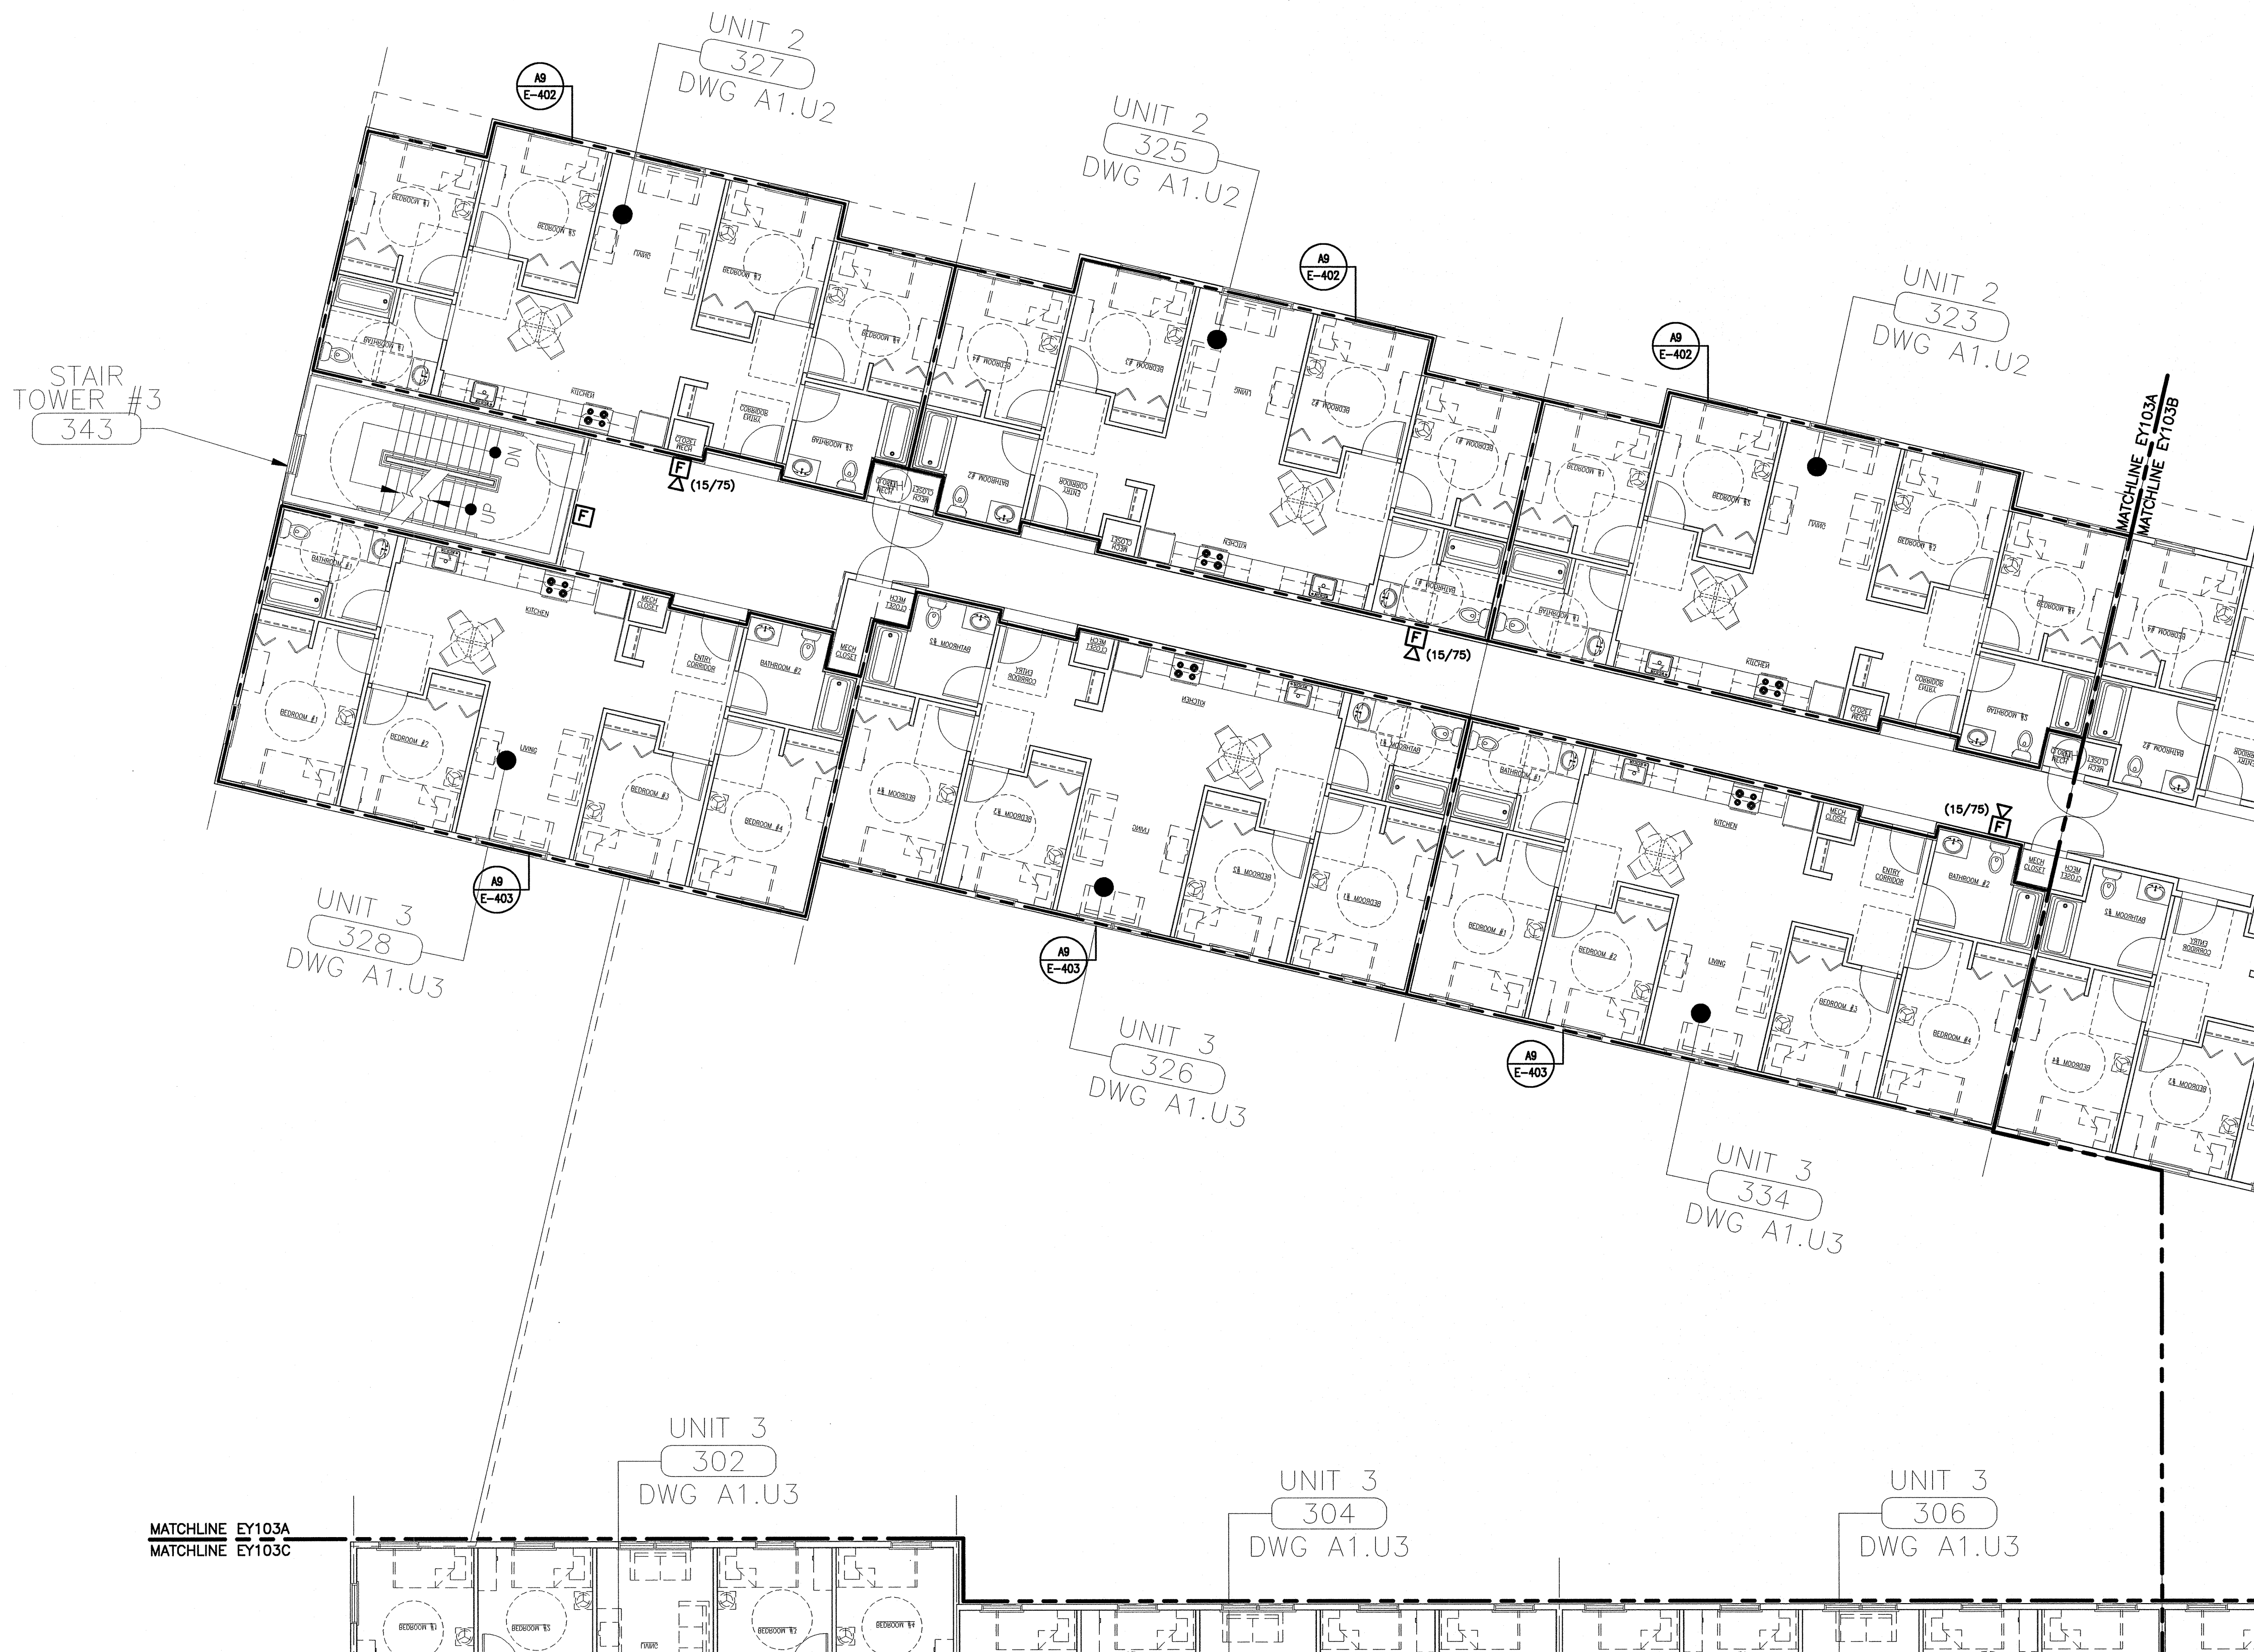

A1 **THIRD FLOOR PLAN**

1/8"=1'-0"