

NOTE:

1. SEE SHEET E-001 FOR LEGEND AND GENERAL NOTES.


ESB
E.S. BOULOS CO
 ELECTRICAL CONTRACTORS

45 BRADLEY DRIVE
 WESTBROOK, ME 04092
 TEL: (207) 464-3706
 FAX: (207) 464-1833

SM
RT

ARCHITECTURE ENGINEERING PLANNING

SMART
 144 Fore Street, P.O. Box 618
 Portland, Maine 04104
 tel. (207) 772-3846
 fax. (207) 772-1070

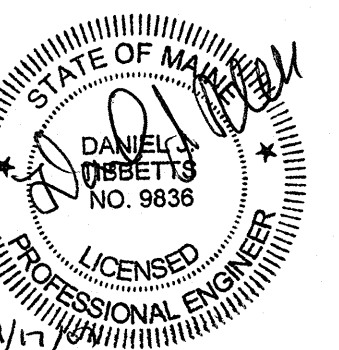

BAYSIDE VILLAGE
STUDENT HOUSING COMPLEX
 PORTLAND, ME

ISSUED FOR CONSTRUCTION
 9-14-07

PROJECT TITLE:

CURRENT ISSUE STATUS:

DATE

DESCRIPTION

REV

0

ISSUED FOR CONSTRUCTION

9-14-07

1"

1/8"=1'-0"

PROJECT MANAGER: DJT

JC/DRAWN BY: CDS

A/E OF RECORD: DJT

CAD FILE: EY104A-07125

PROJECT NO: 07125

DATE: 9-14-07


SHEET TITLE:

FOURTH FLOOR
 SYSTEMS PLAN A

SHEET No.

EY104A

© COPYRIGHT 2007 SMART INC.

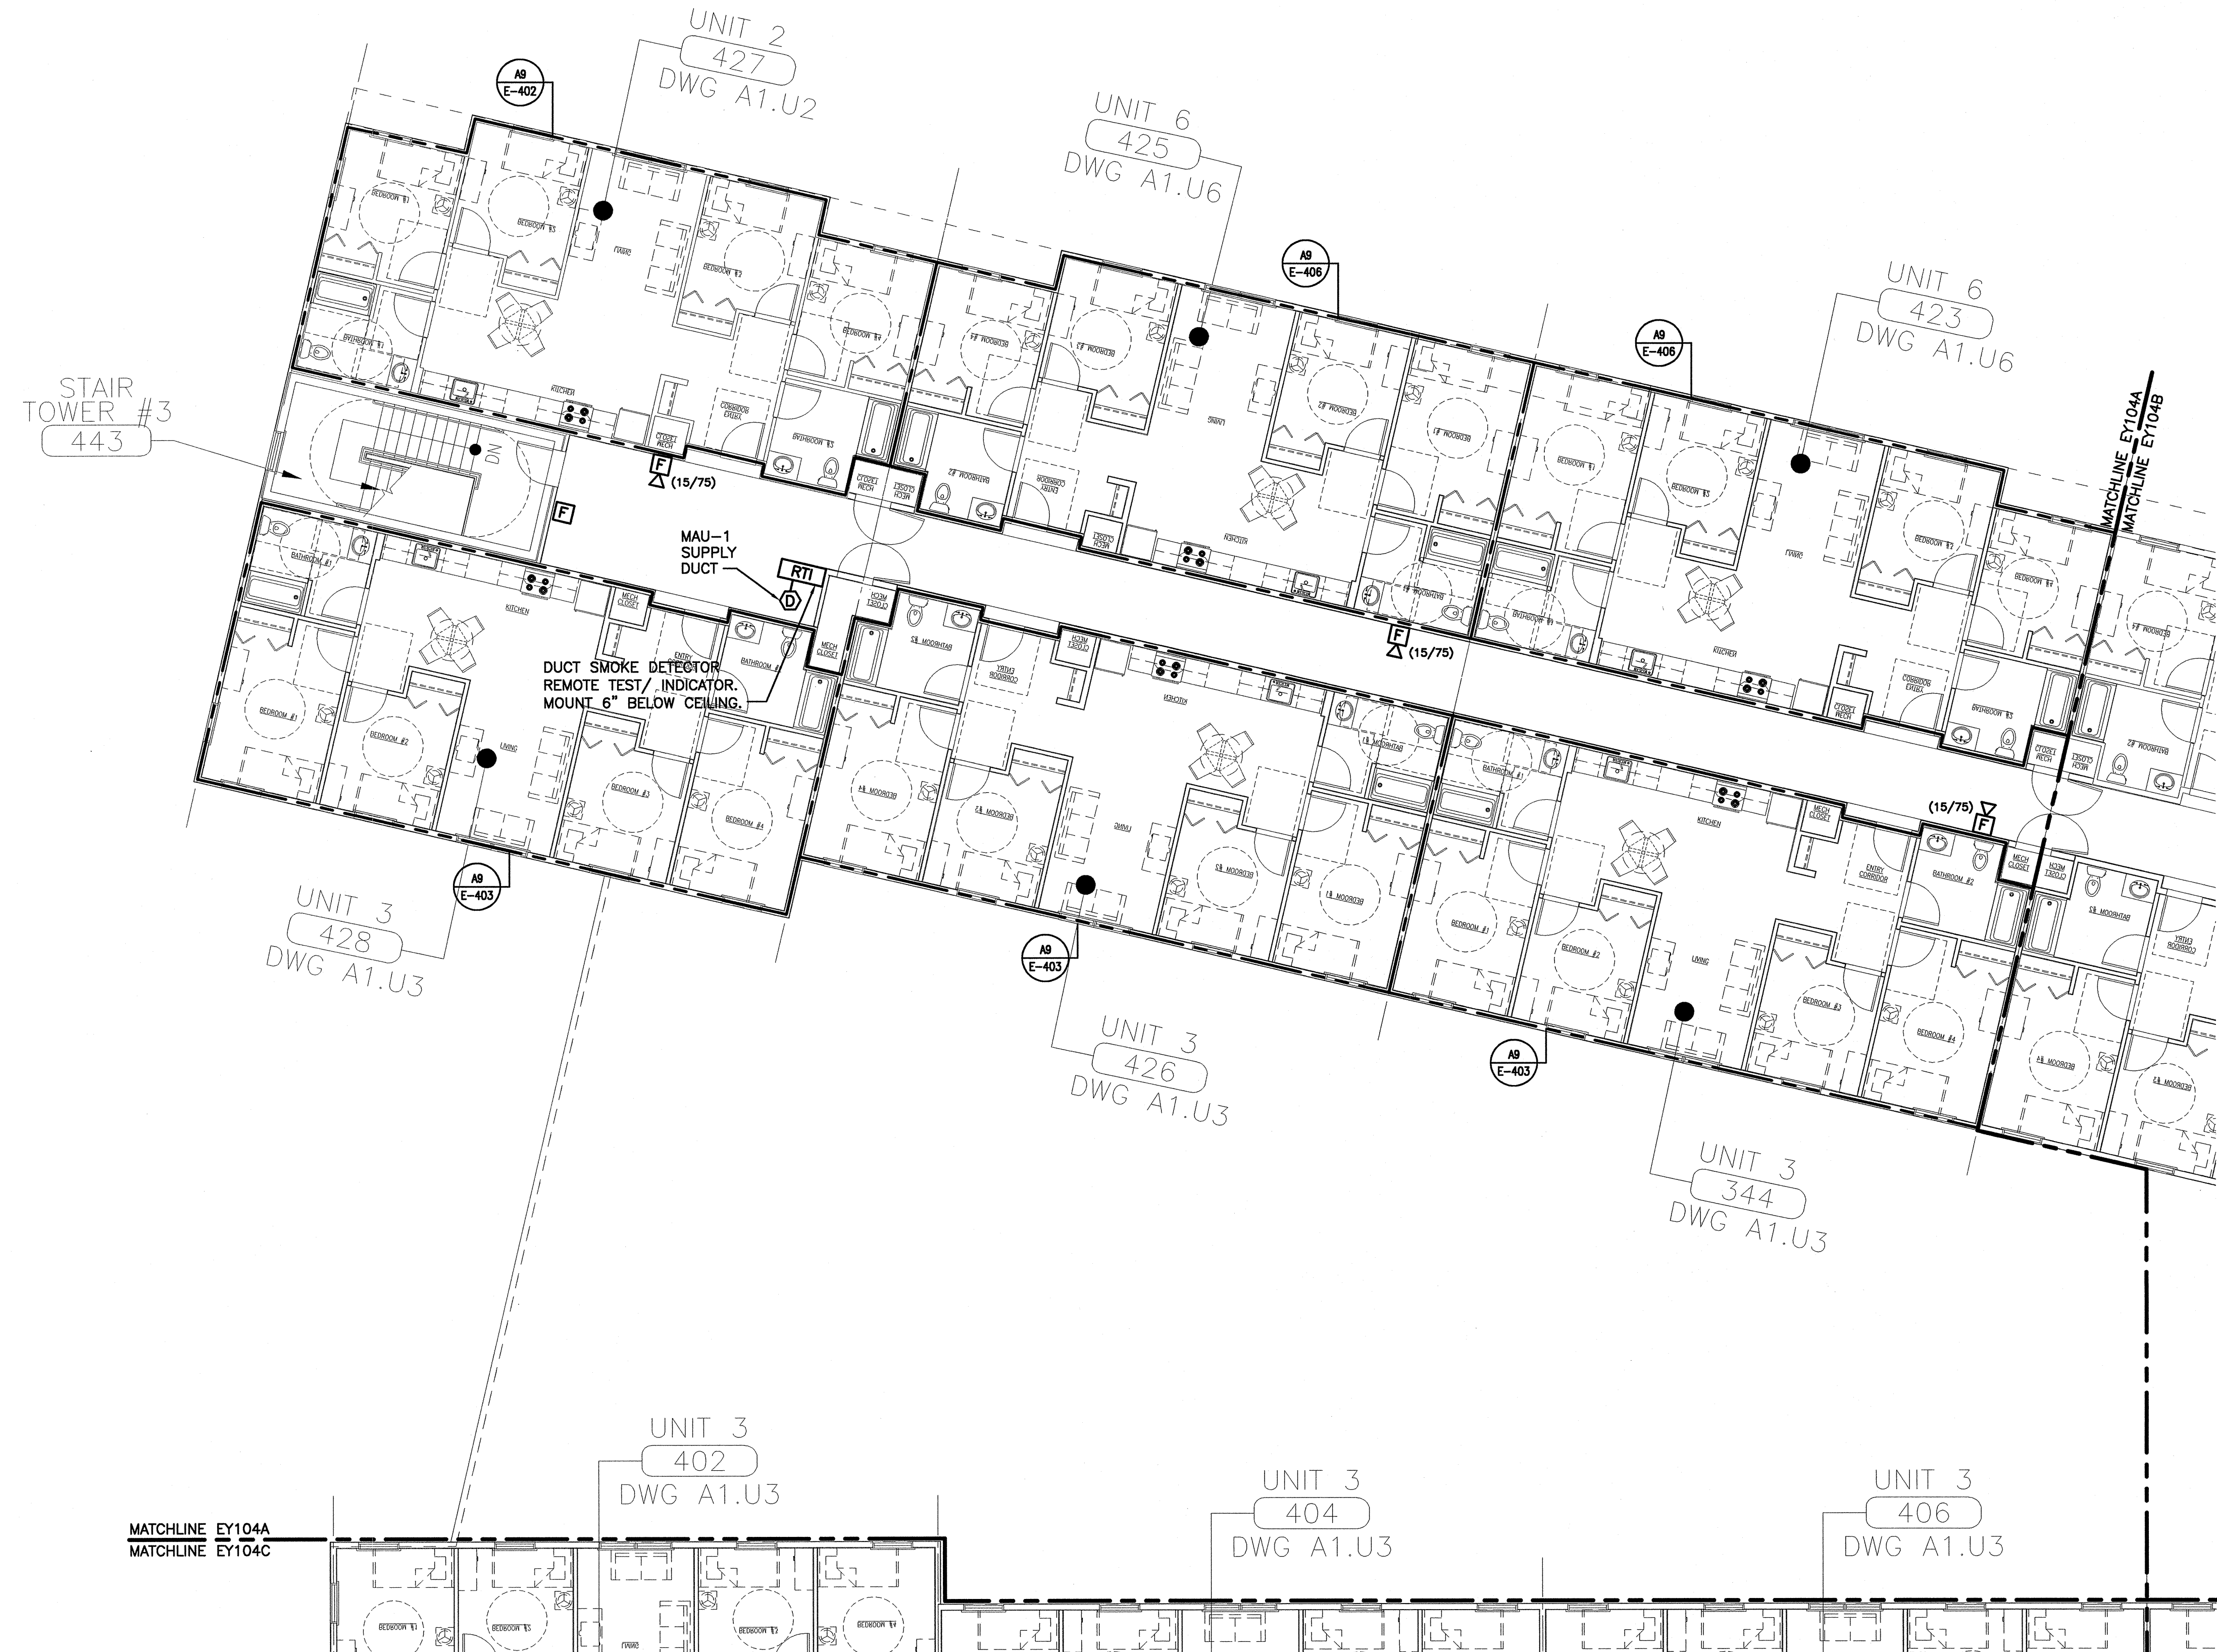

A1 **FOURTH FLOOR PLAN**
 1/8"=1'-0"