


REV.	DESCRIPTION	DATE
1	UPDATED FLOOR PLAN REVISION	11-07-07
	ADDED WATER HEATER VENTS AND INATKES	11-07-07
0	100% CD	08-31-07

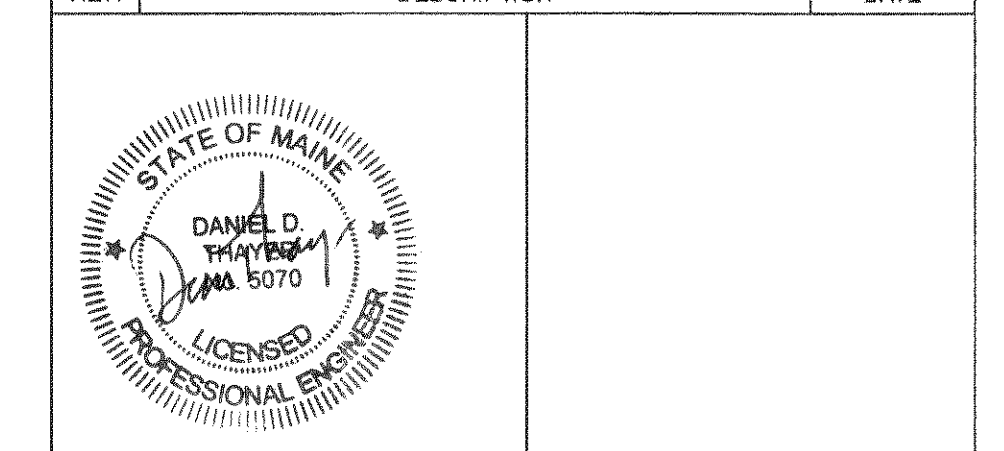

DESIGN/BUILD/MAINTAIN  
**THAYER CORPORATION**  
 1400 Hotel Road  
 AUBURN, MAINE 04211  
 Tel. (207)782-4197 Fax (207)782-1064

PROJECT: BAYSIDE VILLAGE  
 - A STUDENT HOUSING COMPLEX  
 120 MARCONI WAY  
 PORTLAND, MAINE

SHEET TITLE: HVAC ROOF PLAN

SCALE: 1/16" = 1'-0" DATE: 08/15/2007  
 PROJECT MANAGER: ADK  
 JOB CAP/DRAWN: MAS  
 E OF RECORD: DDT  
 THAYER CAD FILE

SHEET No. **M4.5**