




BOILER ROOM PLAN
HYDRONIC PIPING
SCALE: 1/4"=1'-0"

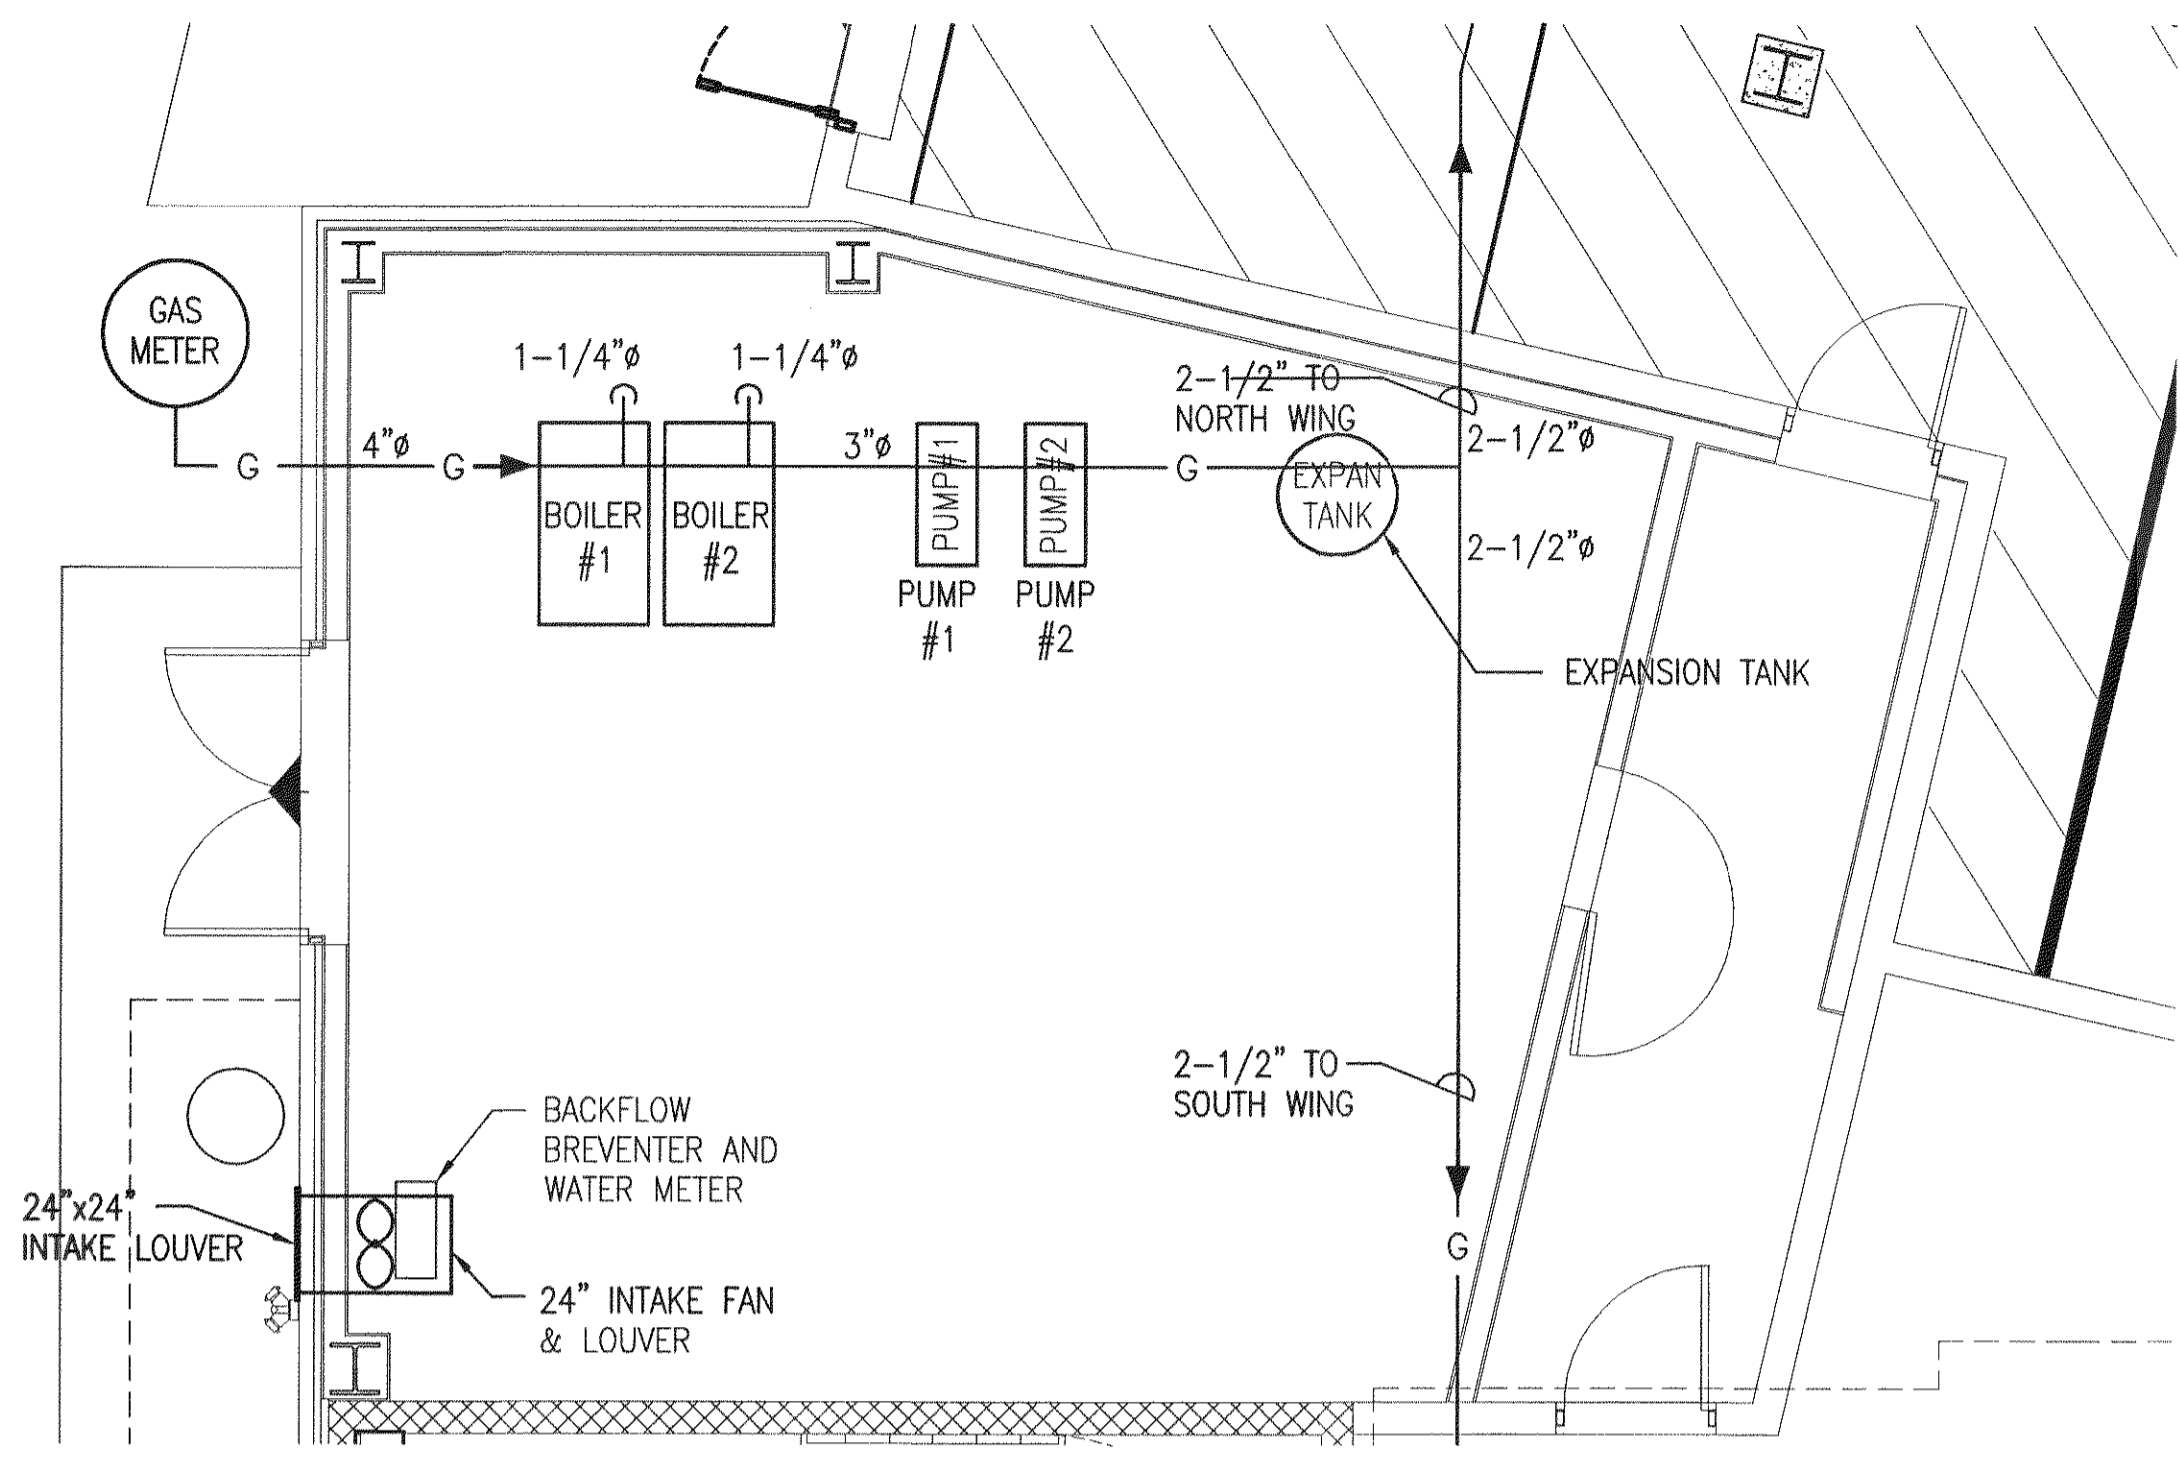


BOILER ROOM PLAN
GAS PIPING
SCALE: 1/4"=1'-0"

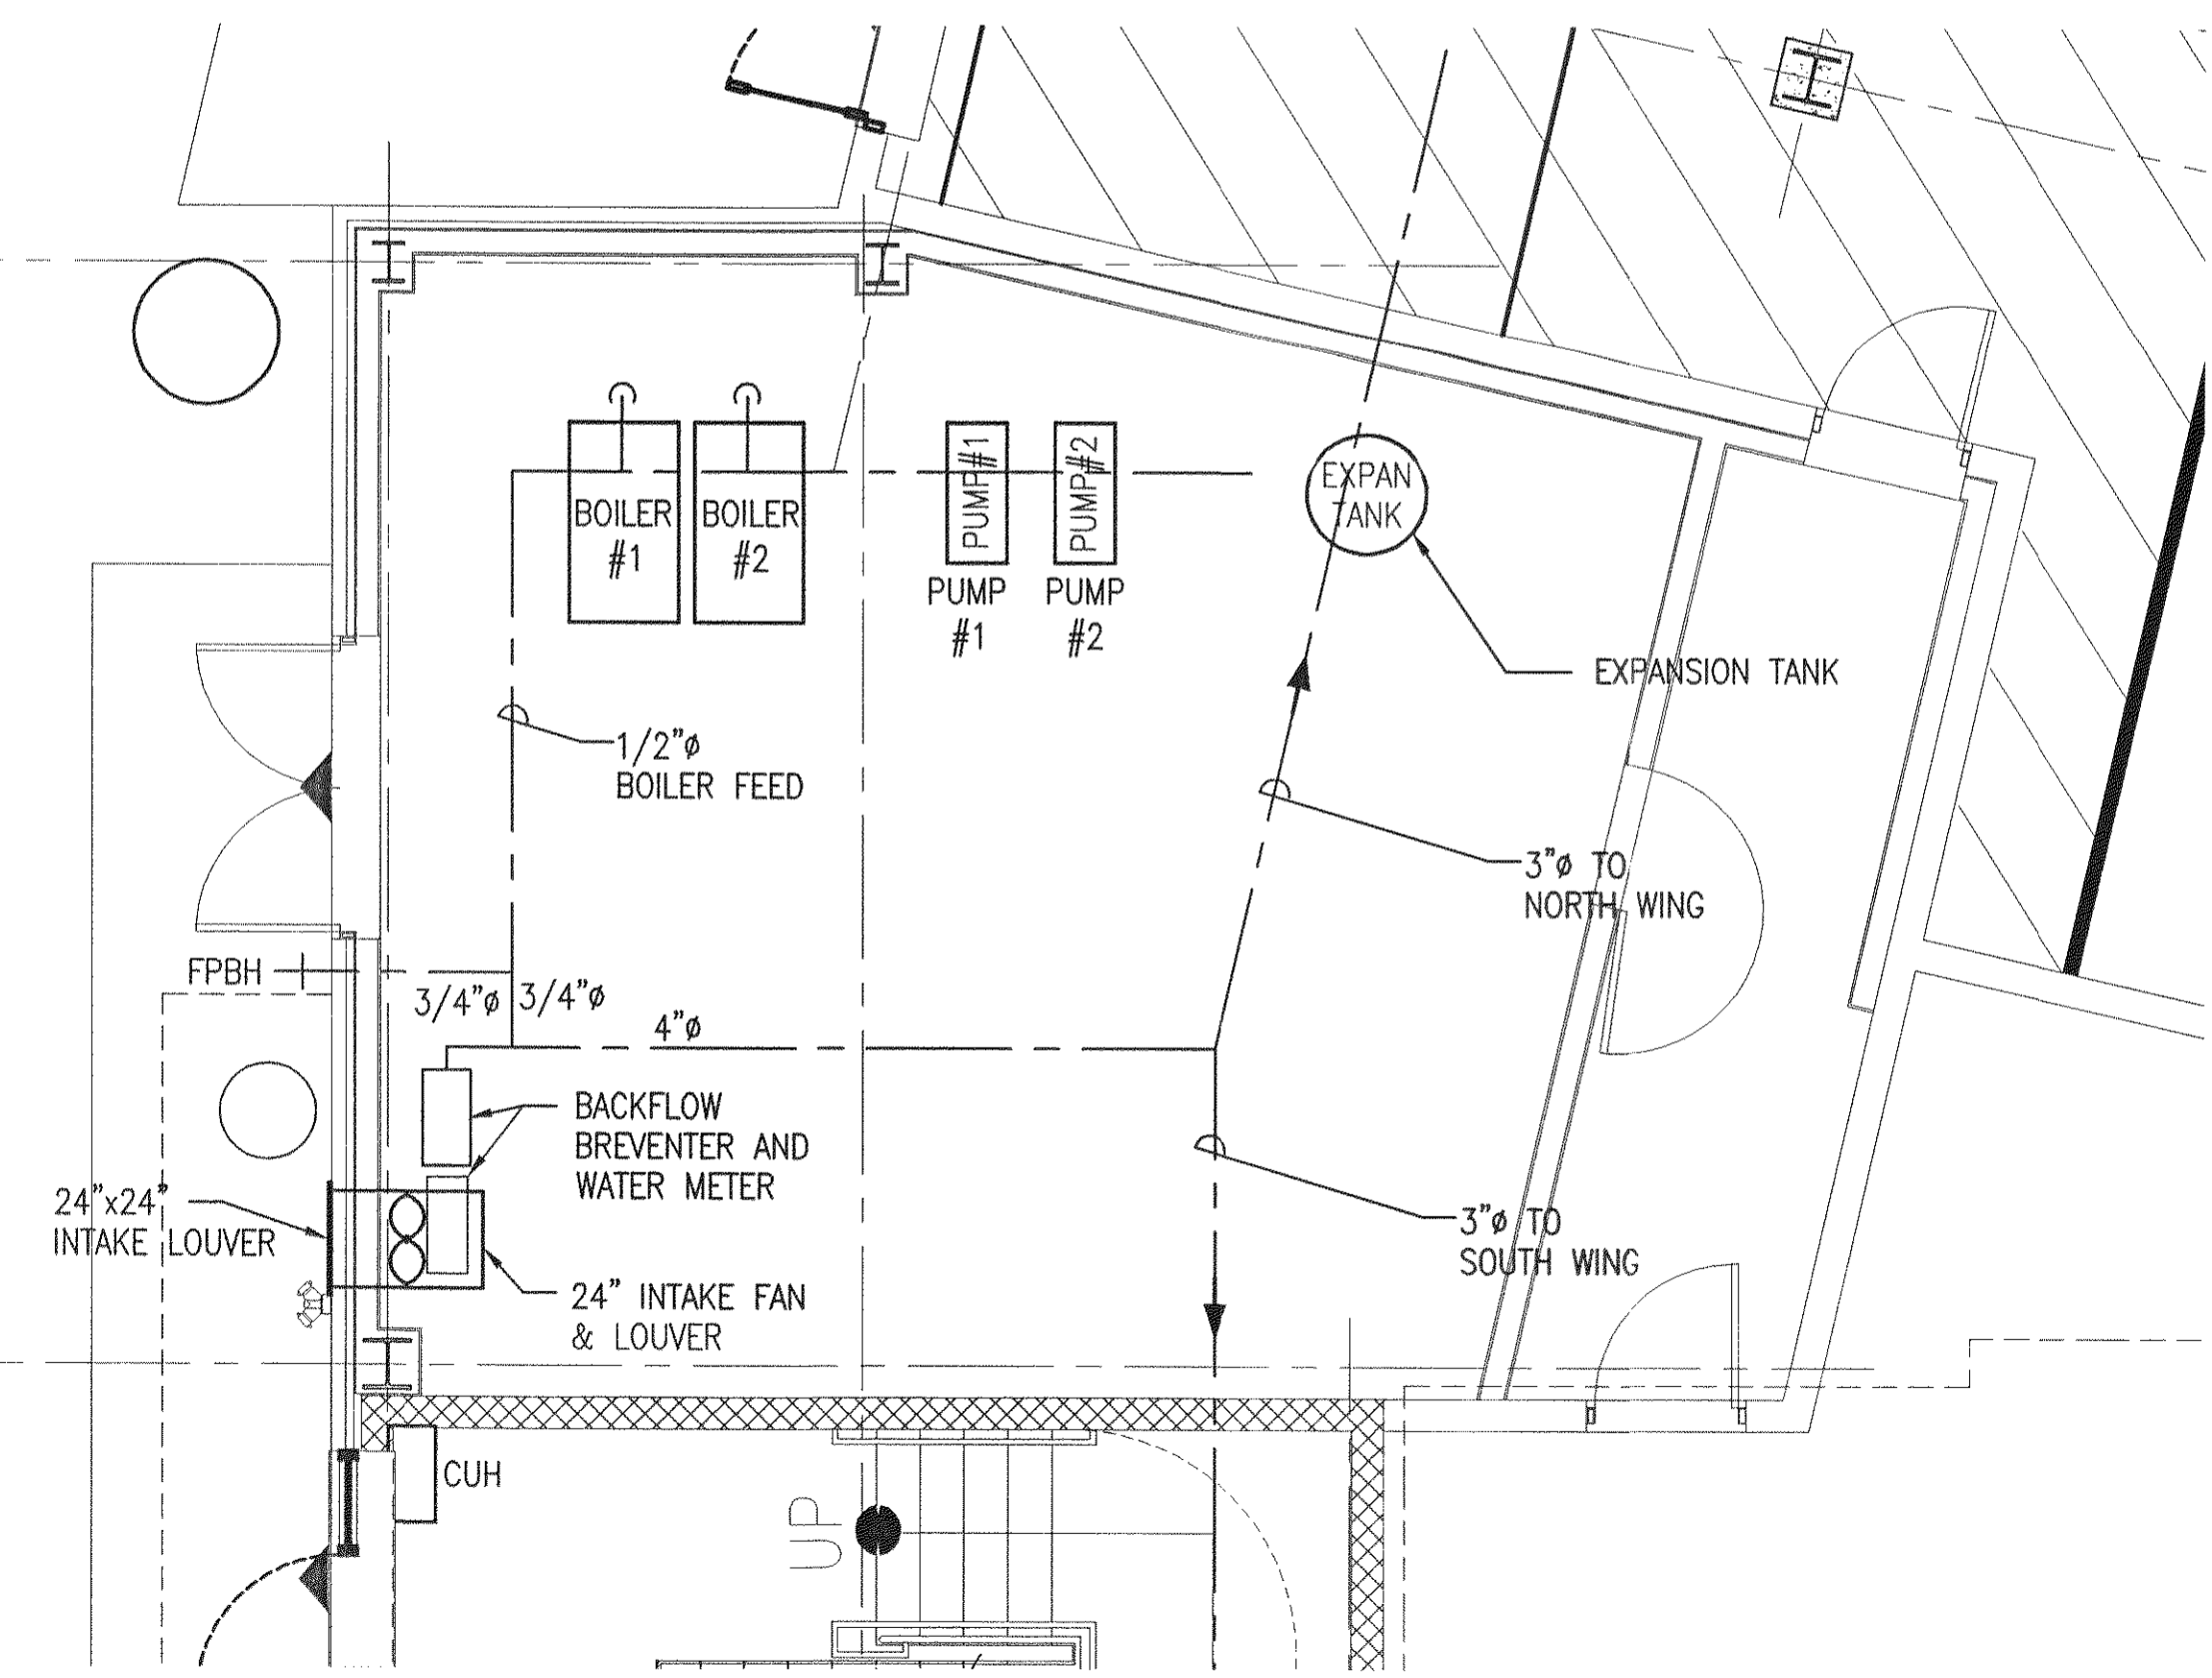

BOILER ROOM PLAN
COLD WATER
SCALE: 1/4"=1'-0"

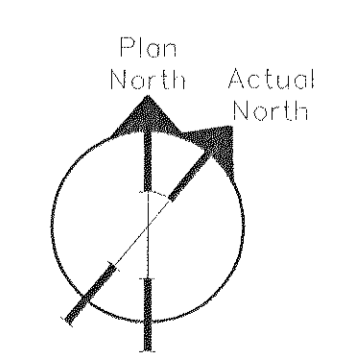

REV.	DESCRIPTION	DATE
1	UPDATED FLOOR PLAN REVISION	11-07-07
0	100% CD	08-31-07

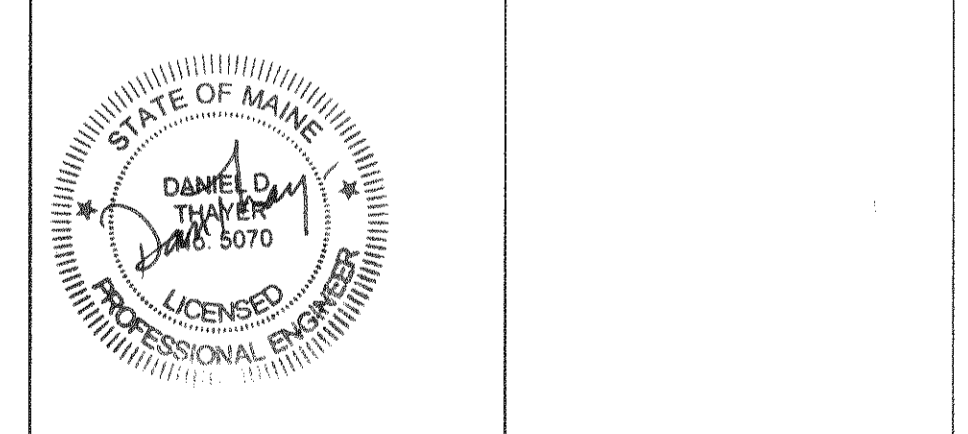

DESIGN/BUILD/MAINTAIN
THAYER CORPORATION
1400 Hotel Road
AUBURN, MAINE 04211
Tel. (207)782-4197 Fax (207)782-1064

PROJECT: BAYSIDE VILLAGE
- A STUDENT HOUSING COMPLEX
120 MARGINAL WAY
PORTLAND, MAINE

SHEET TITLE: BOILER ROOM PLAN AND DETAILS

SCALE: 1/4"=1'-0"	DATE: 08/15/2007
PROJECT MANAGER: ADK	
JOB CAP/DRAWN: MAS	
E OF RECORD: DDT	SHEET No. M8.5
THAYER CAD FILE	