





Winton Scott Architects
5 Milk Street
Portland, Maine 04101
207 774 4811
www.wintonsscott.com

Architecture / Planning
Preservation Architecture
Interior Architecture

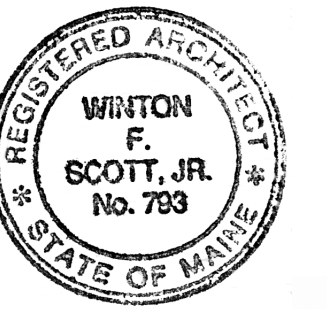

Winton Scott

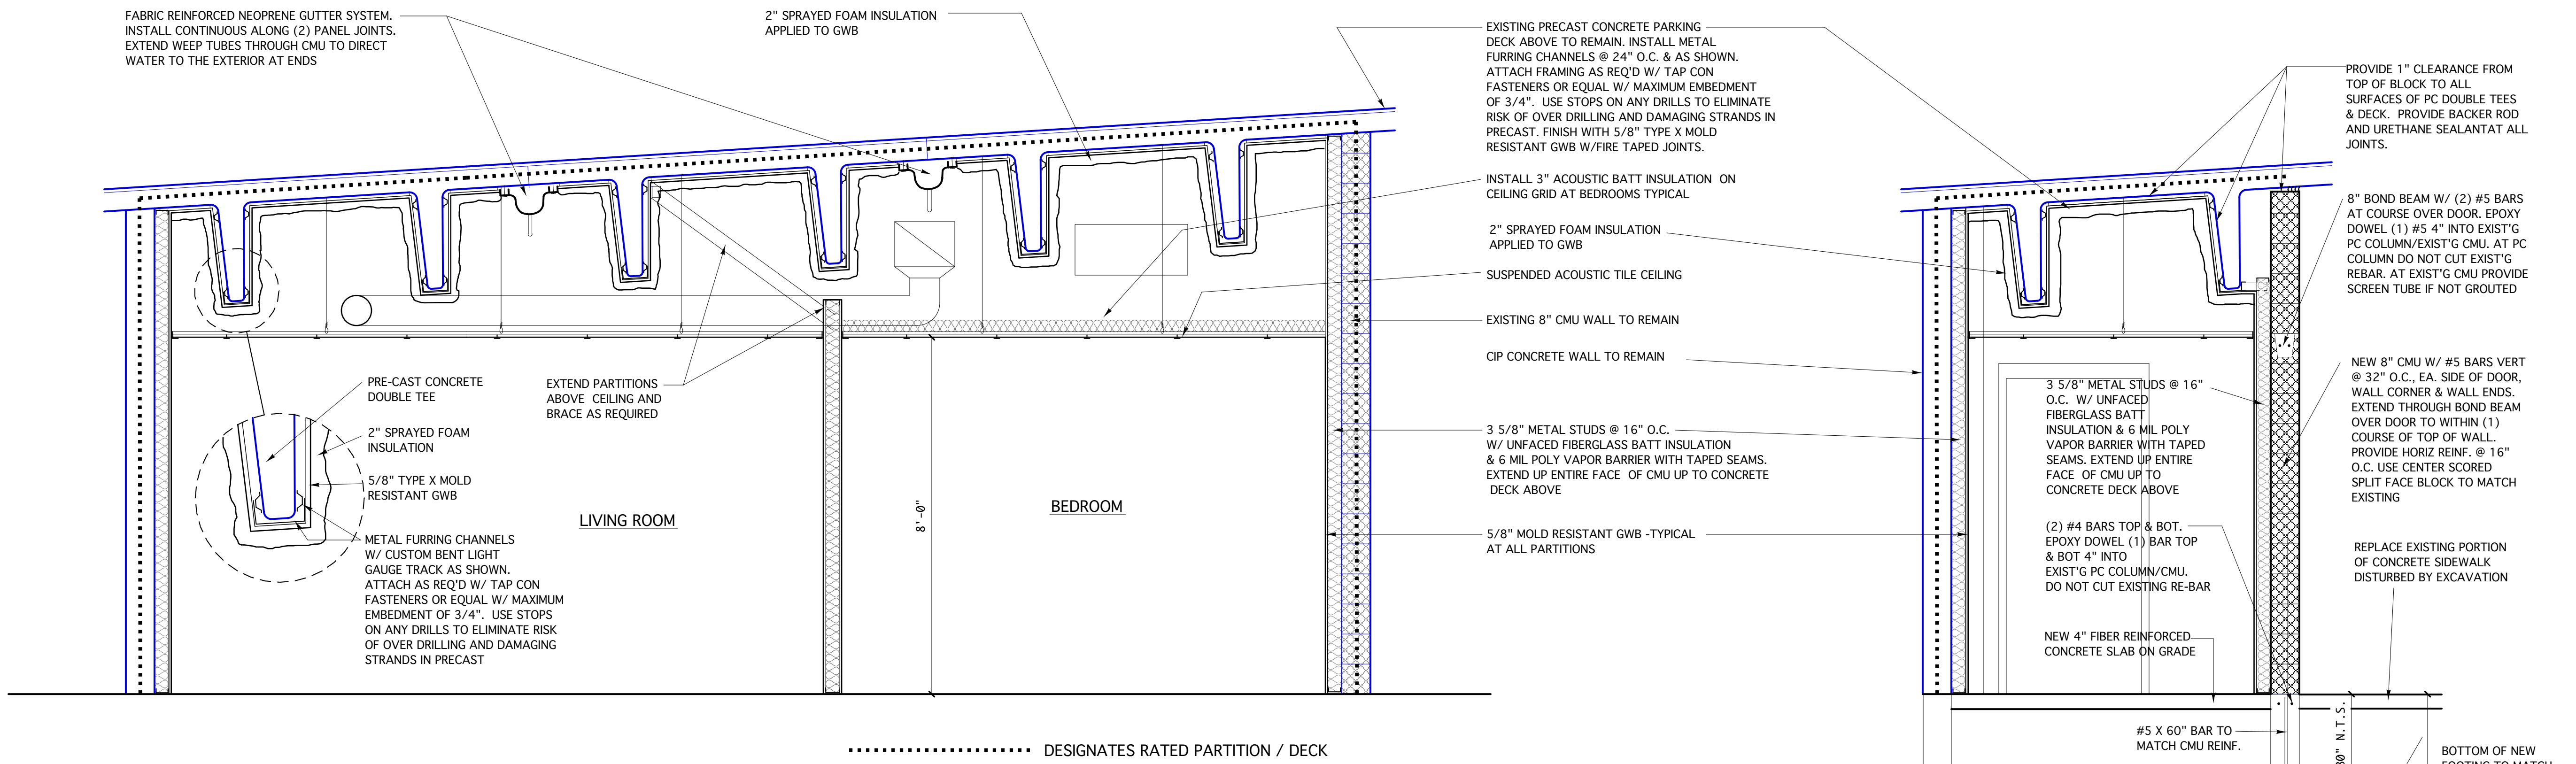


BUILDING SECTION A-A

SCALE: 1/2" = 1'-0"


BUILDING SECTION B-B

SCALE: 1/2" = 1'-0"

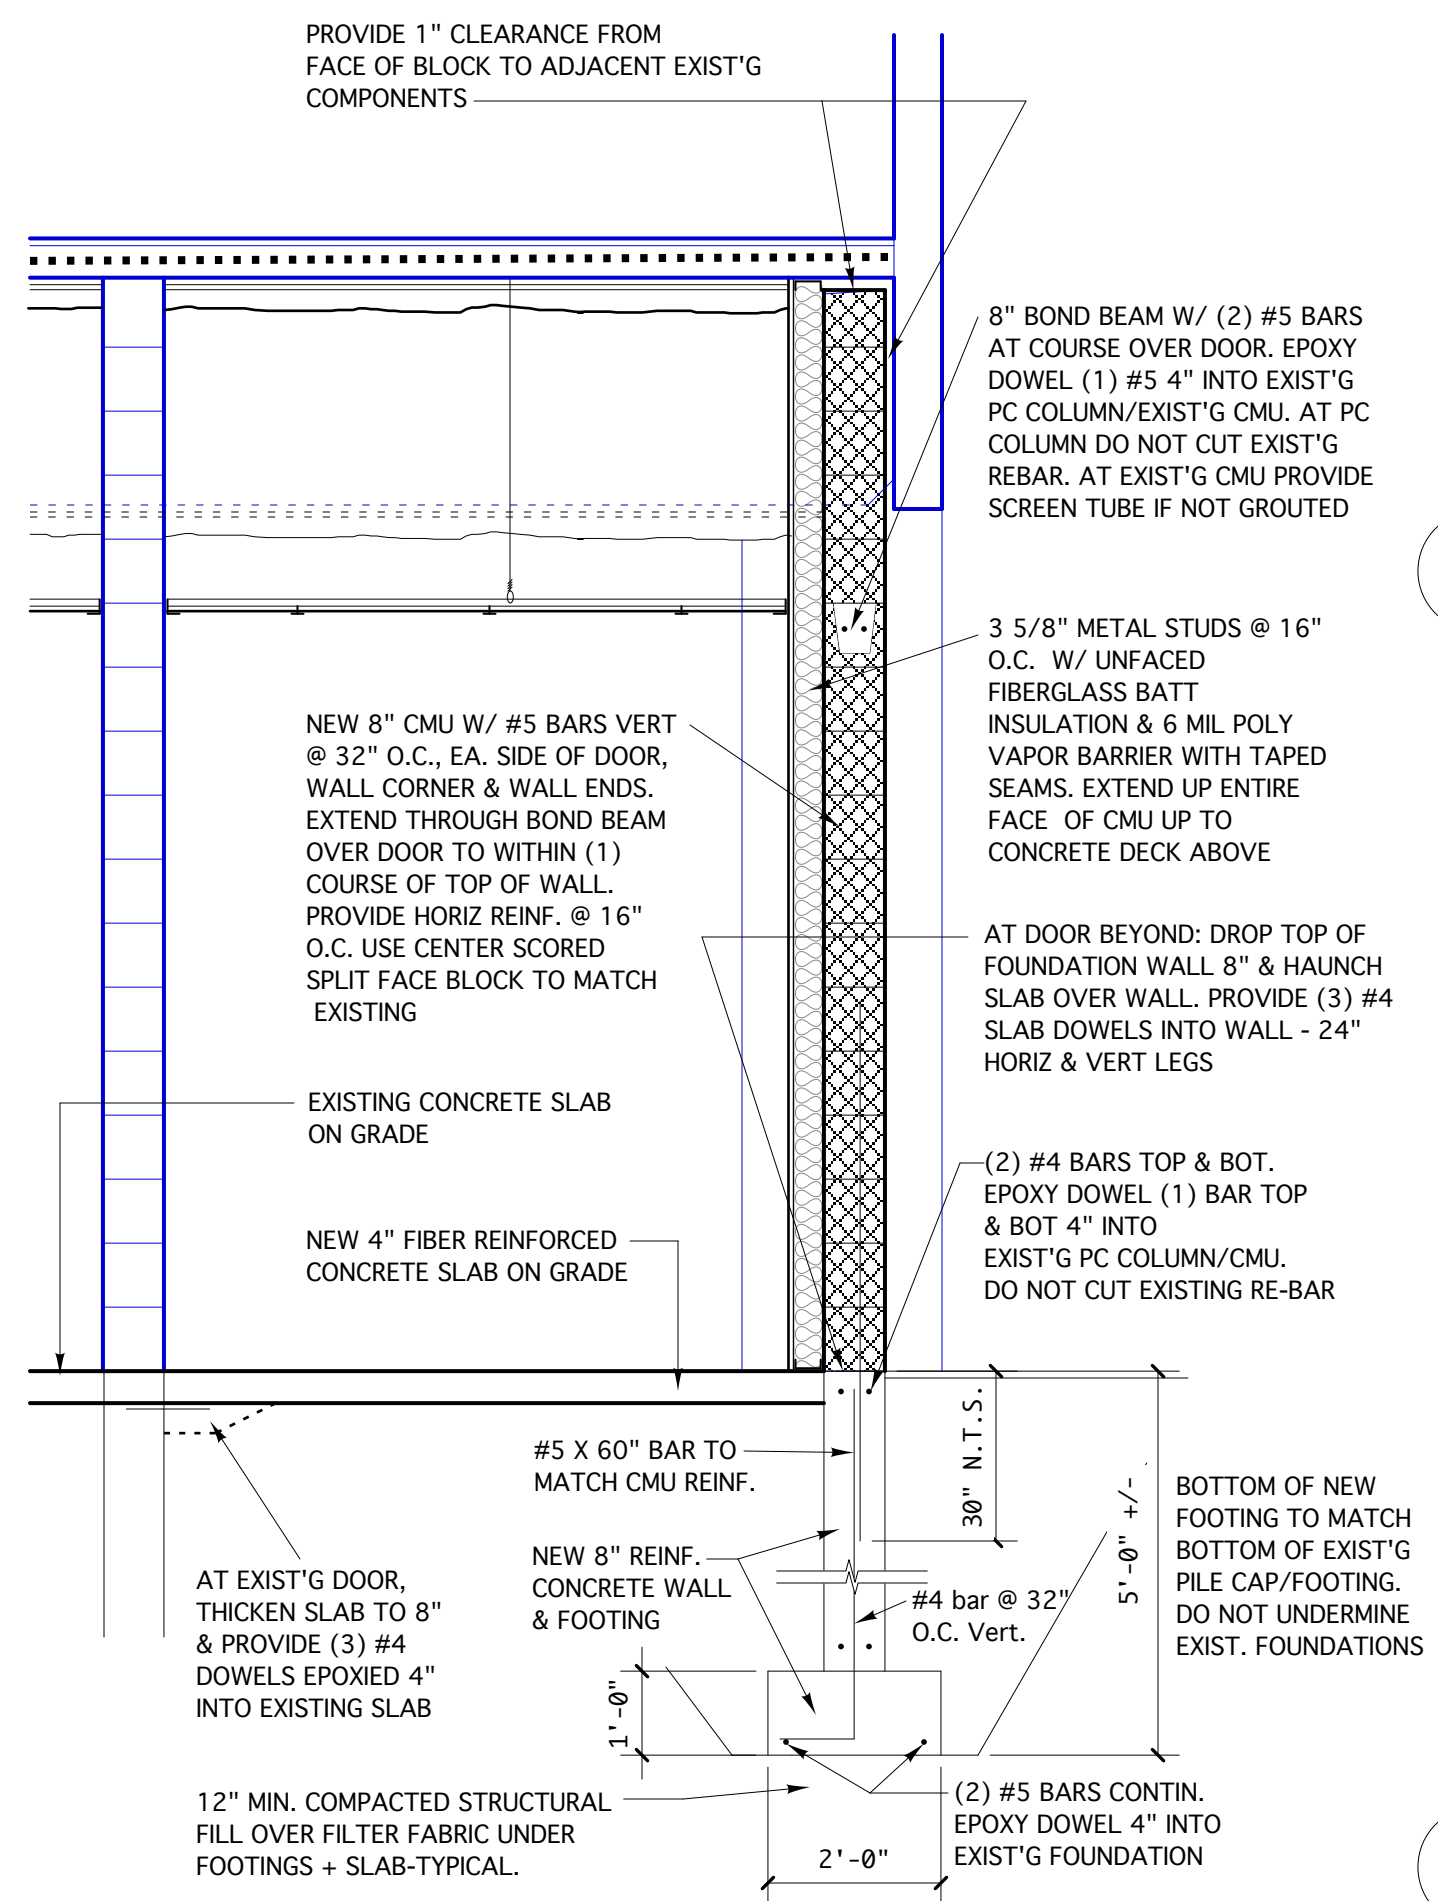

BUILDING SECTION C-C

SCALE: 1/2" = 1'-0"

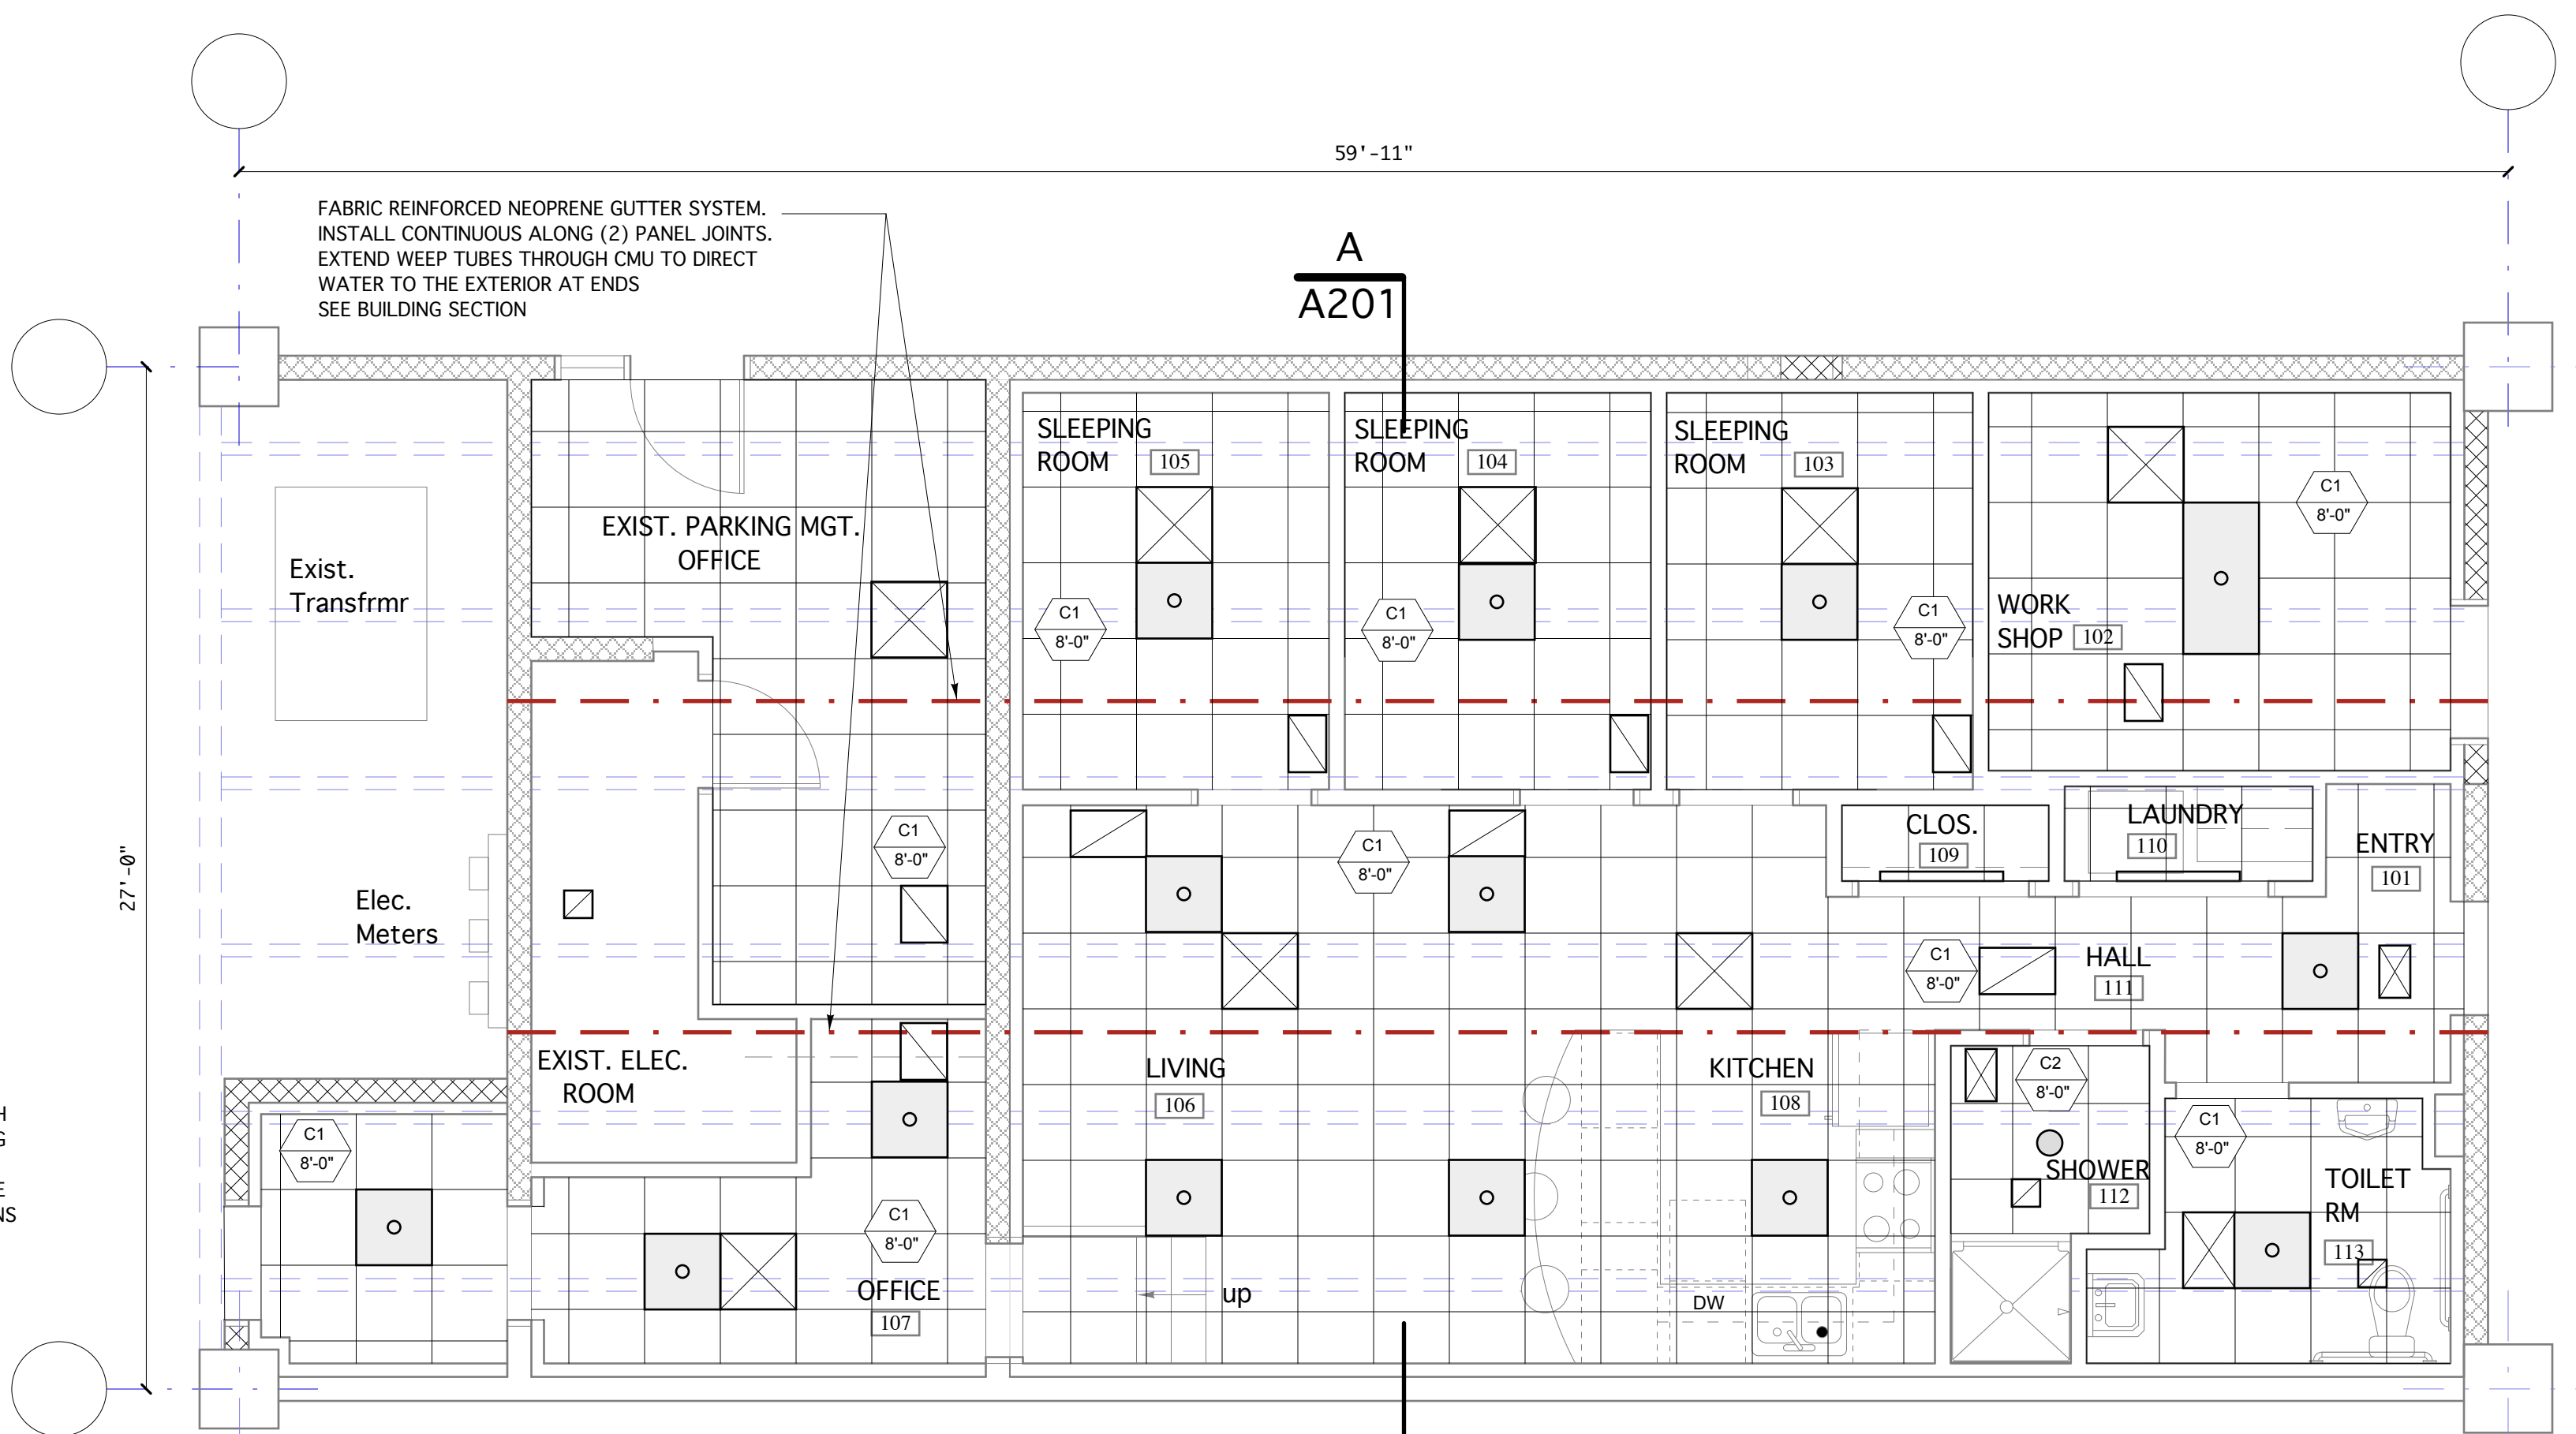

CEILING PLAN

SCALE: 1/4" = 1'-0"

CEILING LEGEND	
	Indicates ceiling type
	Indicates ceiling height from finish floor to underside of ceiling finish
	Suspended acoustical ceiling tiles.
	Painted GWB soffit.
CEILING TYPES	
C1	2'x2' suspended acoustical ceiling tiles.
C2	2'x2' suspended acoustical cgl tiles for humid environment
MECHANICAL LEGEND	
EQUIPMENT IS SHOWN FOR COORDINATION PURPOSES ONLY. LAYOUT IS NOT EXTENSIVE. REFER TO MECHANICAL DRAWINGS AND SPECIFICATIONS FOR MORE DETAILS.	
	AIR SUPPLY GRILLE OR EXHAUST REGISTER. SEE MECH.
	AIR RETURN GRILLE OR EXHAUST REGISTER. SEE MECH.
LIGHT FIXTURES LEGEND	
FIXTURES ARE SHOWN FOR LOCATION PURPOSES ONLY. REFER TO ELECTRICAL DRAWINGS AND SPECIFICATIONS FOR MORE DETAILS.	
	RECESSED FLUORESCENT FIXTURE.
	RECESSED FLUORESCENT FIXTURE.
	RECESSED DOWNLIGHT FIXTURE.

Renovations To:

City of Portland
Fireboat Crew
Quarters

Main State Pier
Portland, Maine

CONSTRUCTION DOCUMENTS
October 22, 2012

Building Section &
Ceiling Plan

Scale: As Noted

A 201