



E1 SANITARY PIPING DEMOLITION PLAN
1/8" = 1'-0"

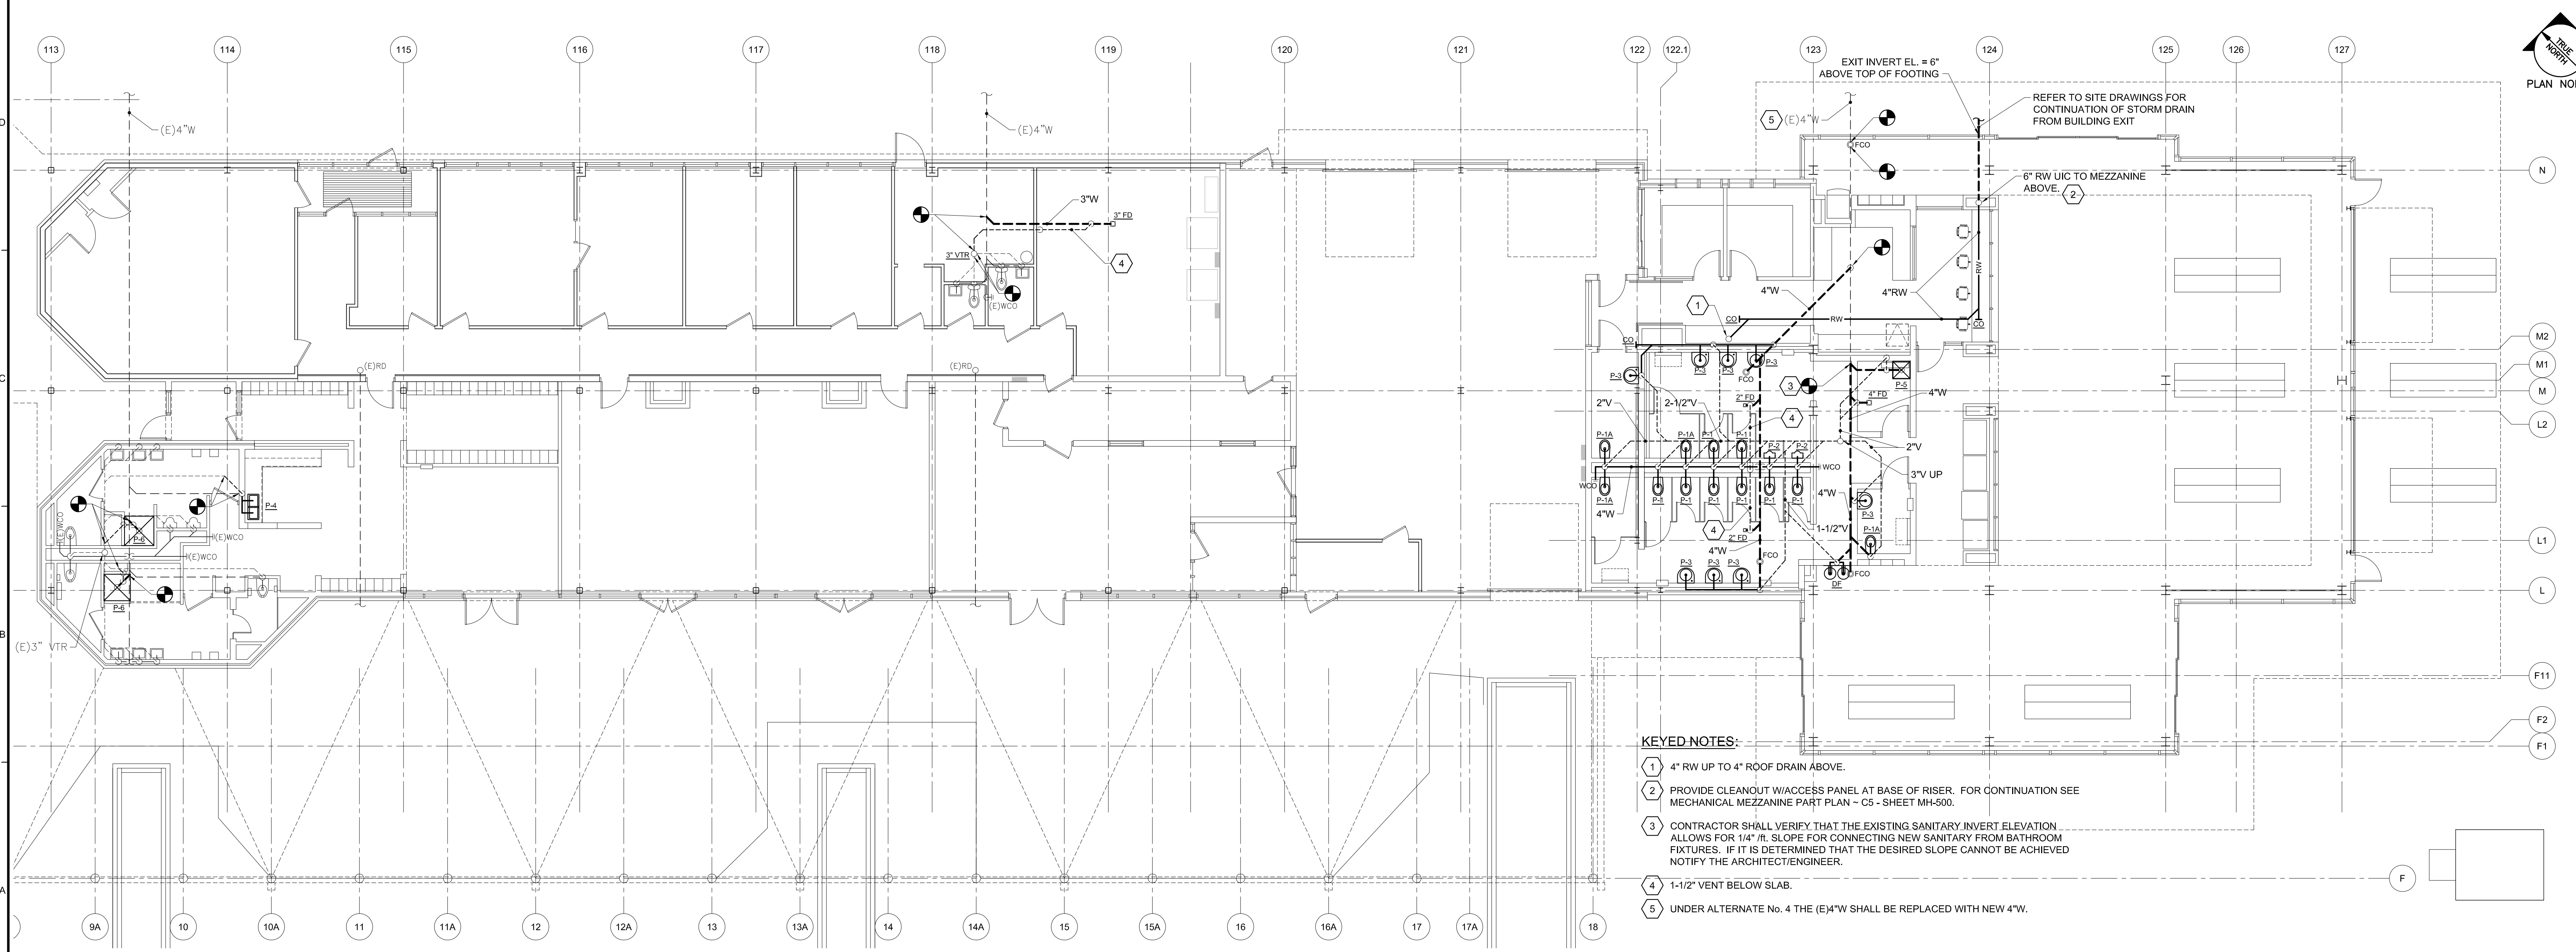

A1 SANITARY PIPING PLAN
1/8" = 1'-0"

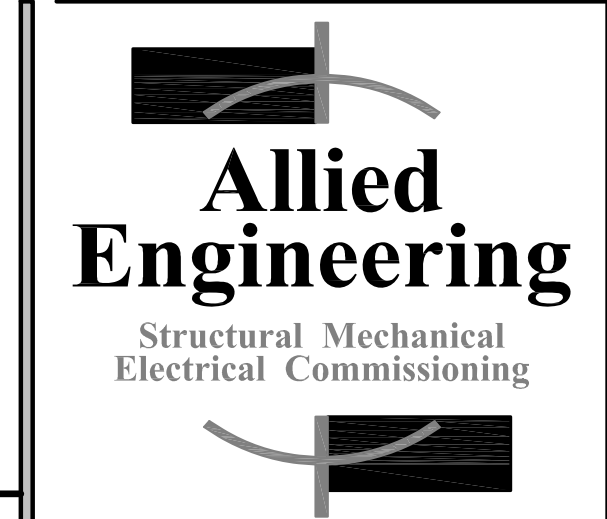


**160 Veranda Street
Portland, Maine 04103**
T: 207.221.2260
F: 207.221.2266
Web: www.allied-eng.com

Allied Project No: 12008
Cad File: 12008M.dwg
Checked By: IAM



PROJECT NAME:
**CASCO BAY FERRY
TERMINAL**
RENOVATIONS & ADDITIONS
56 COMMERCIAL STREET
PORTLAND, MAINE 04101

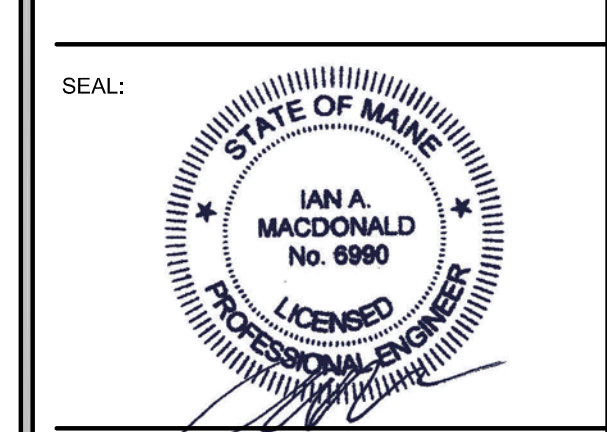

REVISION:

NO.	DATE	DESCRIPTION
1	DATE	
2	DATE	
3	DATE	
4	DATE	
5	DATE	
6	DATE	

DATE OF ISSUE: MAY 14, 2013
PROJECT NUMBER: 2011-0270
STATUS: ISSUED FOR BIDDING

**SANITARY
PIPING
PLANS**

PL-100
2008 © Scott Simons Architects LLC

N:\Projects\2013\12008 - Casco Bay Ferry Terminal\01 Drawing Files\12008M.dwg May 13, 2013 8:22am