



**E1 DOMESTIC PIPING DEMOLITION PLAN**  
1/8" = 1'-0"

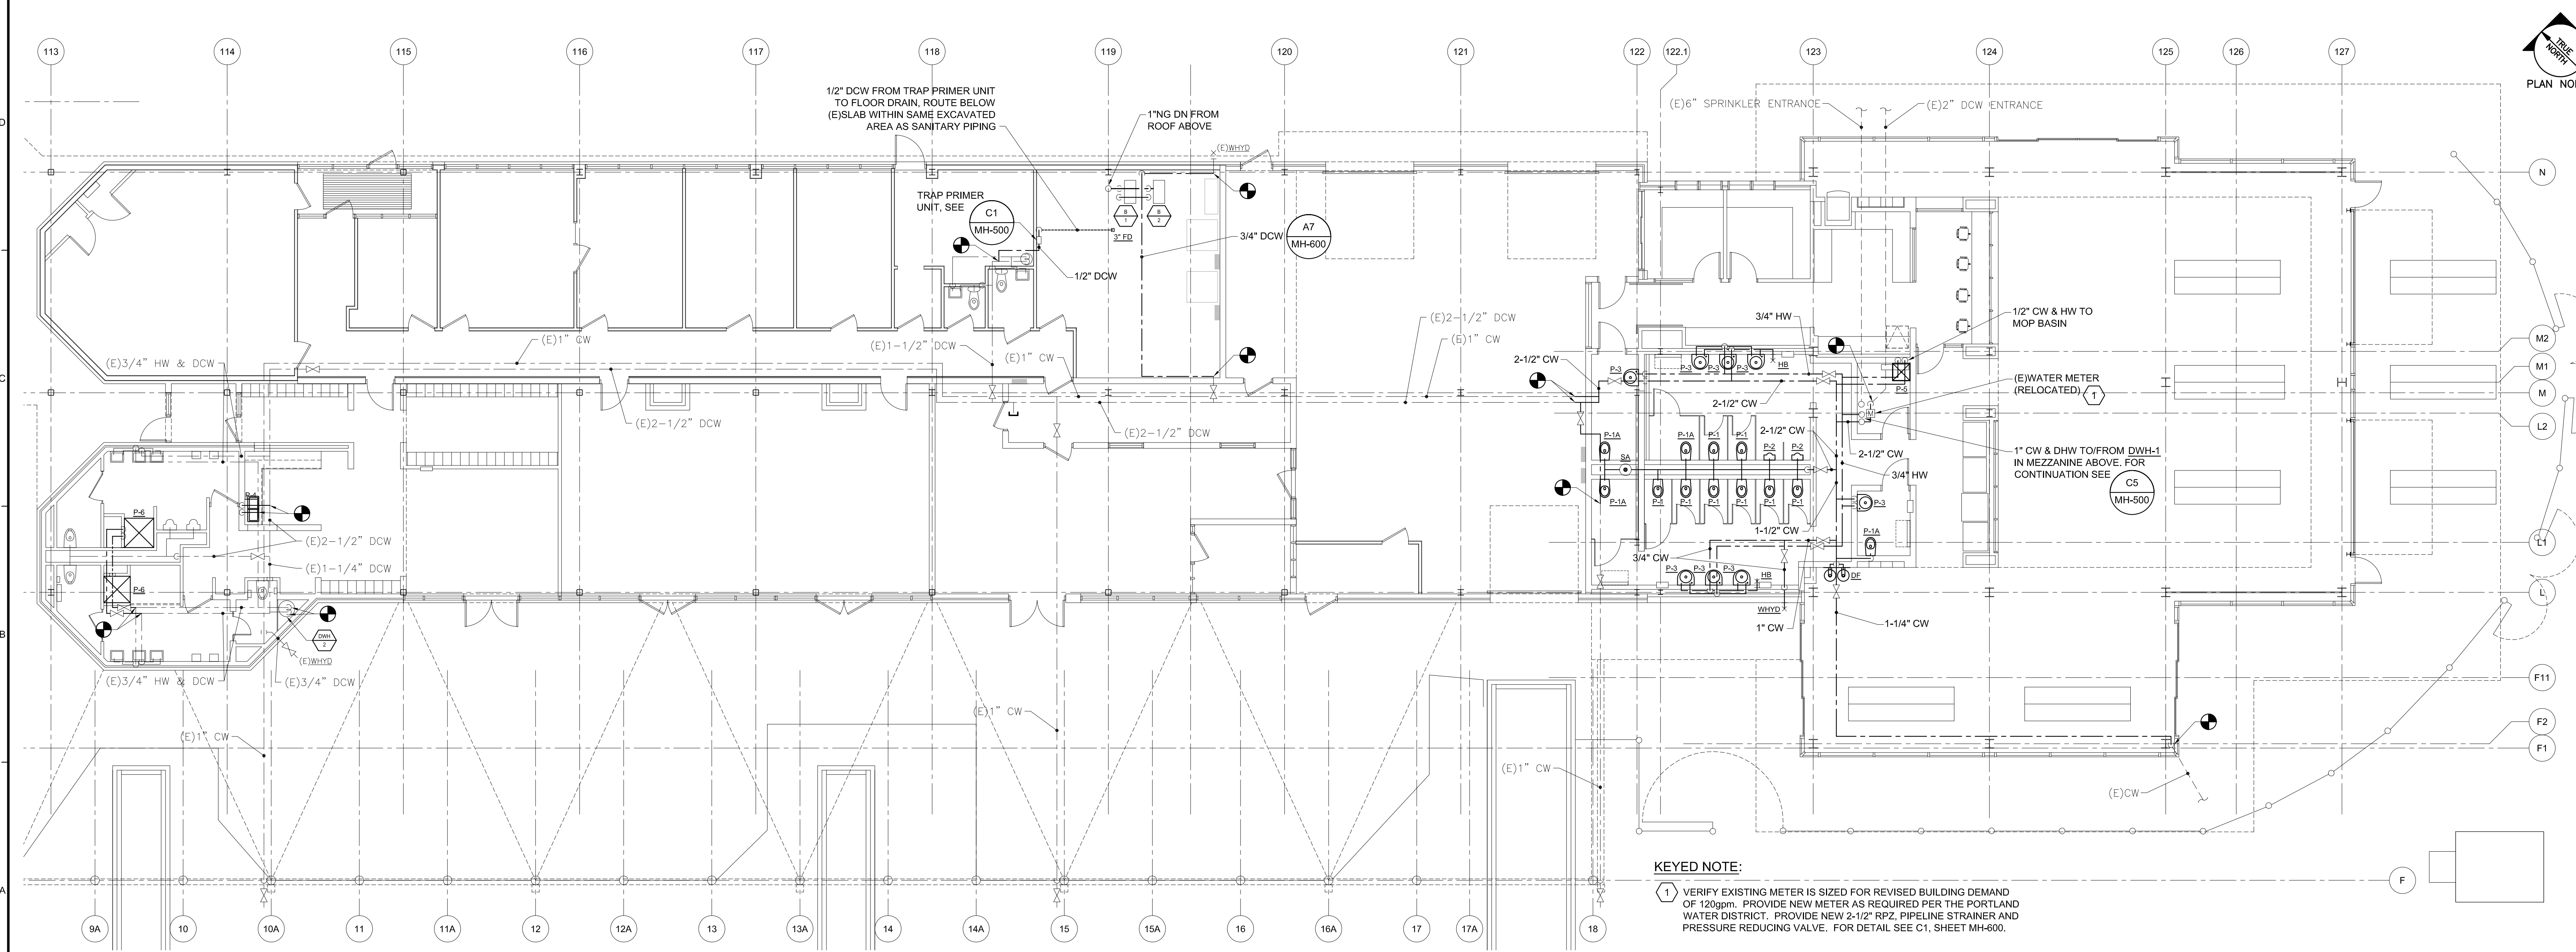

**A1 DOMESTIC PIPING PLAN**  
1/8" = 1'-0"

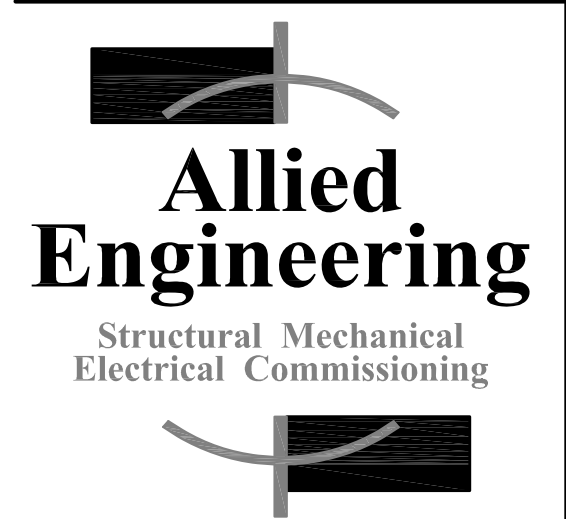


**160 Veranda Street  
Portland, Maine 04103**  
T: 207.221.2260  
F: 207.221.2266  
Web: www.allied-eng.com

Allied Project No: 12008  
Cad File: 12008M.dwg  
Checked By: IAM



PROJECT NAME:  
**CASCO BAY FERRY TERMINAL**  
RENOVATIONS & ADDITIONS  
56 COMMERCIAL STREET  
PORTLAND, MAINE 04101

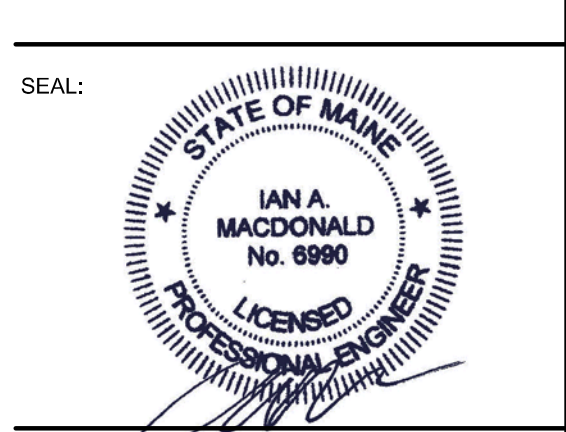

THIS DRAWING IS THE PROPERTY OF SCOTT SIMONS ARCHITECTS (SSA) AND IS NOT TO BE COPIED OR REPRODUCED IN PART OR WHOLE. ©2012 SCOTT SIMONS ARCHITECTS, LLC

REVISION:

NO.	DATE
1	DATE
2	DATE
3	DATE
4	DATE
5	DATE
6	DATE

DATE OF ISSUE: MAY 14, 2013  
PROJECT NUMBER: 2011-0270  
STATUS: ISSUED FOR BIDDING

**DOMESTIC PIPING PLANS**

N:\Projects\2012\Casco Bay Ferry Terminal\01 Drawing Files\12008M.dwg May 13, 2013 8:20am