


LEGEND:

RISER SYM	DWG SYM	DESCRIPTION	CATALOG #
FACP	FACP	Fire Alarm Control Panel	Comwell-FCI E3
F WP	F	Manual Pull Station	MSTAF RMS-1TWP-KL
SD	S	Smoke Detector w/Base	ASD-PLZF ADB-FL
SD	SD	Duct Smoke Detector w/Base	DNR
RTS		Remote Test Switch for Duct Smoke Detector	RTS-451KEY
MM		Addressable Input Module	AQM-2RF
WF	WF	Waterflow Switch	FBO
TS	TS	Tamper Switch (Valve Supervisory)	FBO
PS	PS	Pressure Switch (Dry Sprinkler Alarm)	FBO
STR	STR	Strobe Unit (# Indicates Candela Setting)	STR
STR	STR	Speaker/Strobe Unit (# Indicates Candela Setting)	ESQ-24MCW-FR ET70WP-2475WFR

Scale: 1/8" = 1'

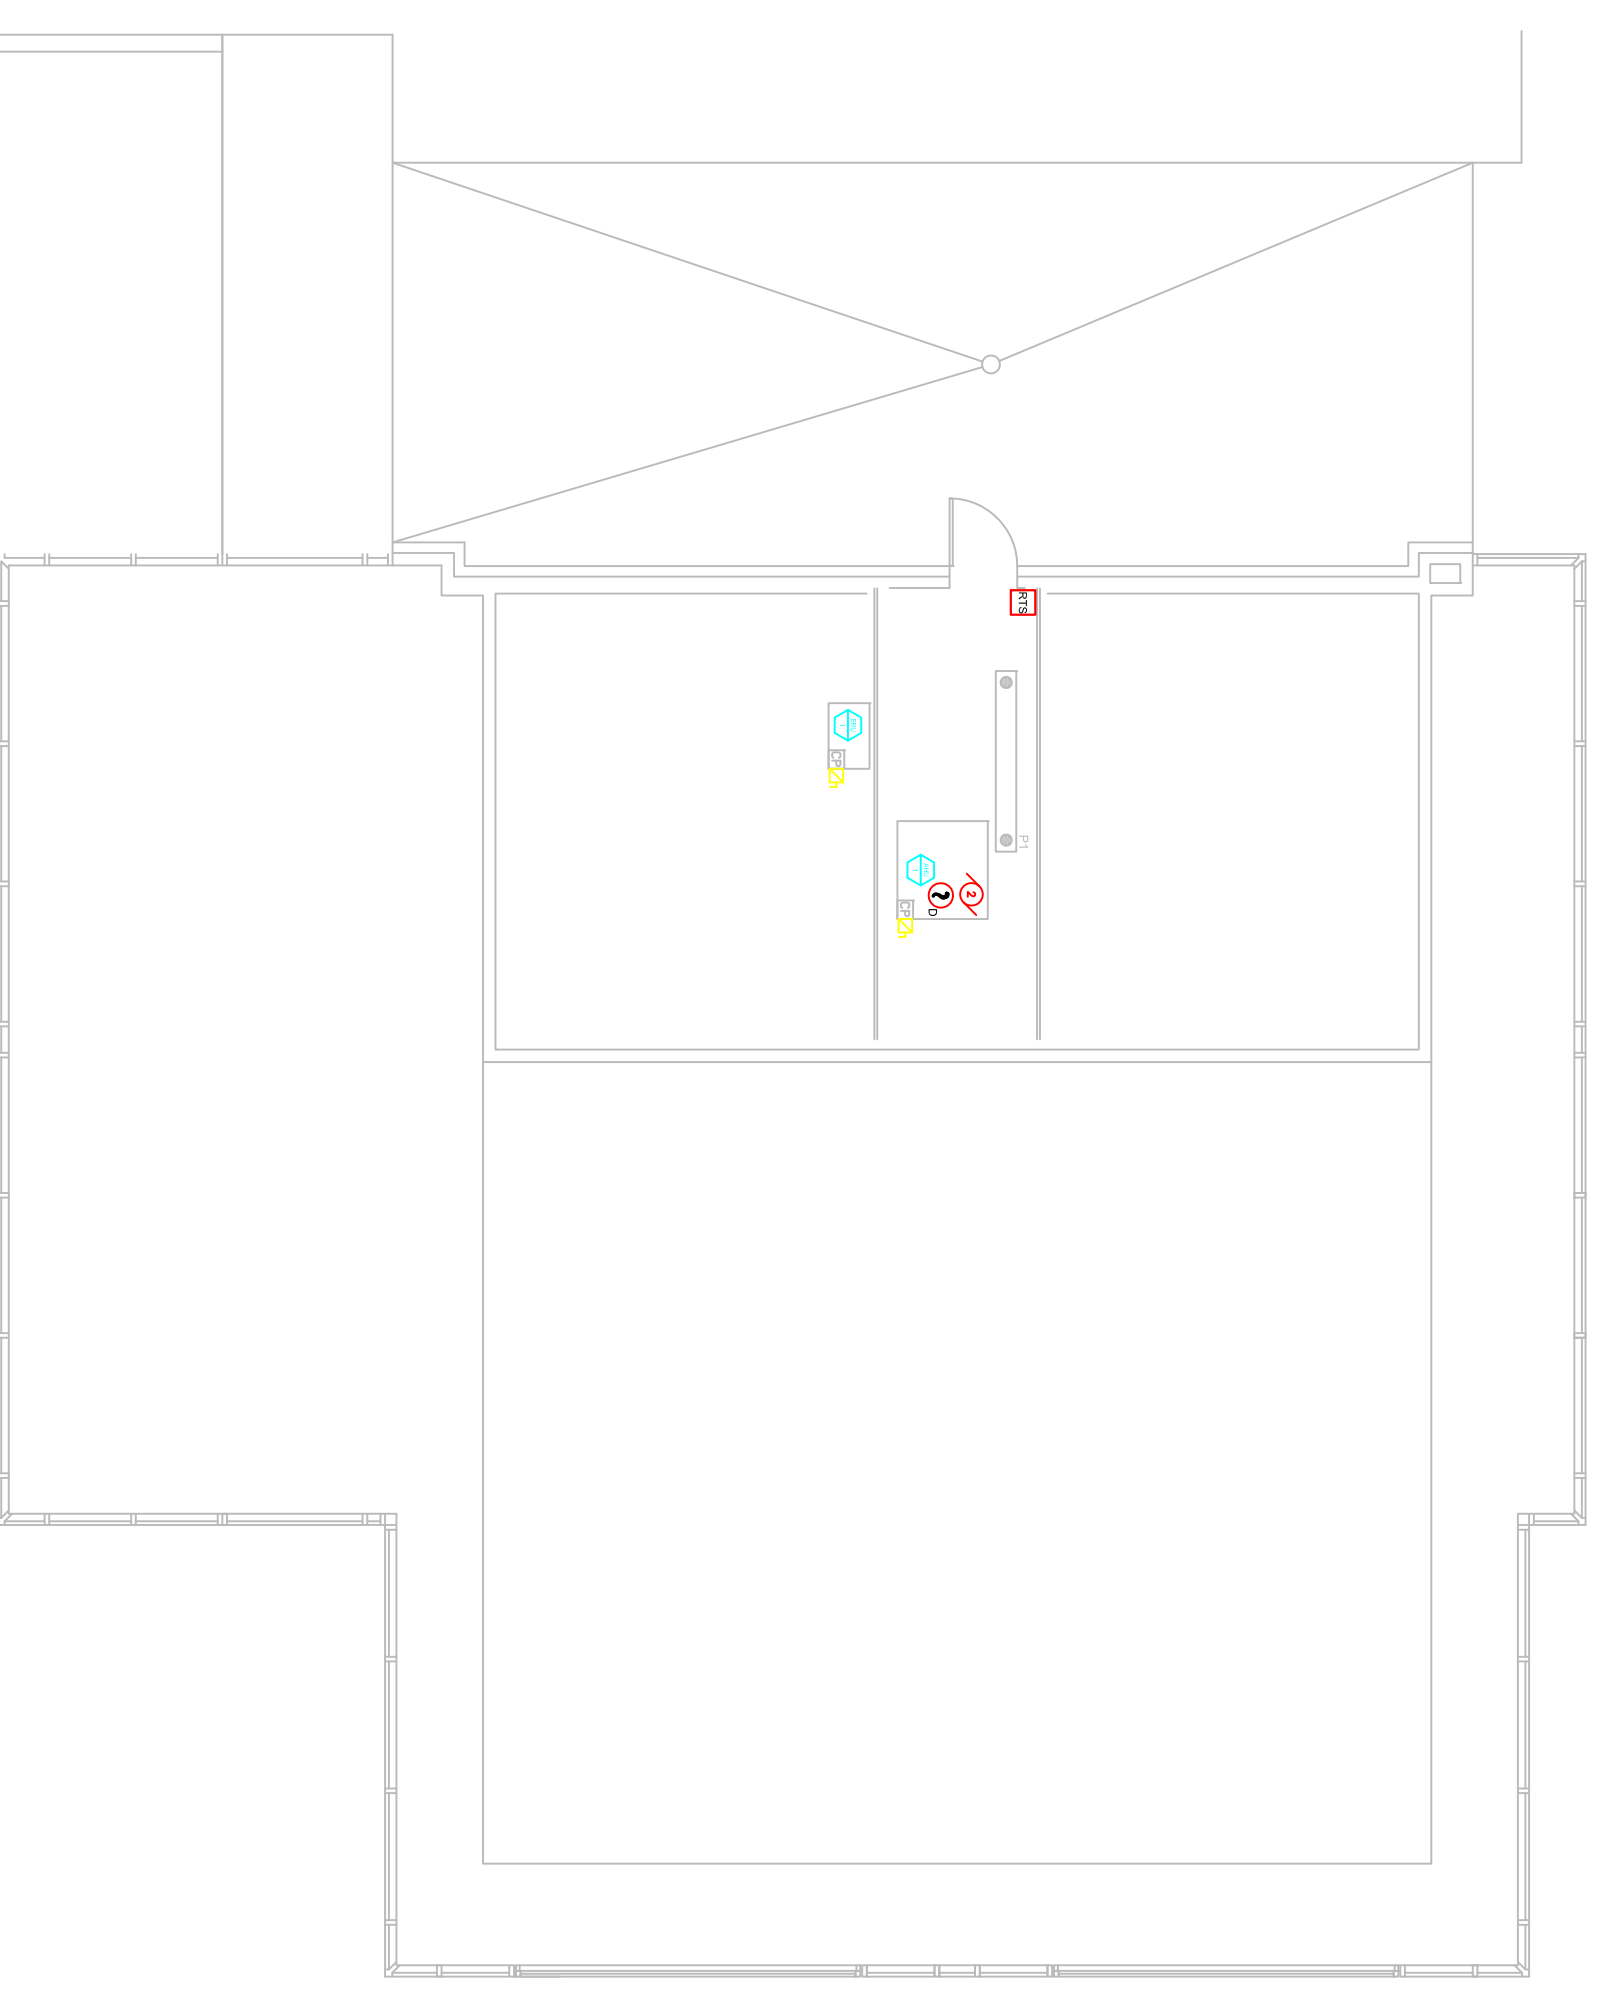

DWG NAME:
Casco Bay Ferry
56 Commercial St
Portland, Maine
FIRE ALARM FLOOR PLAN
DWG NAME: FA02_CASCO_FP

R.B. Allen Co., Inc.
P.O. BOX 770
131 LAFAYETTE RD
NO. HAMPTON, NH 03862
1-800-255-7264

JOB NAME:
Casco Bay Ferry Terminal
56 Commercial St
Portland, Maine
FIRE ALARM FLOOR PLAN

SCALE: 1/8" = 1'		DATE	DRWN:	TRD:
0	Original Issue	6/14	KMB	TRD
REV.	DESCRIPTION	DATE	DRWN:	RWD:

PT No. 84289
Casco Bay Ferry
56 Commercial St
Portland, Maine
DWG NO. FA02_CASCO_FP