


**DEMOLITION KEYED NOTES:**  
 1 REMOVE (E)EXHAUST ROOF JACK.

**E1 MECHANICAL DEMOLITION PLAN ~ ROOF**  
 1/8" = 1'-0"

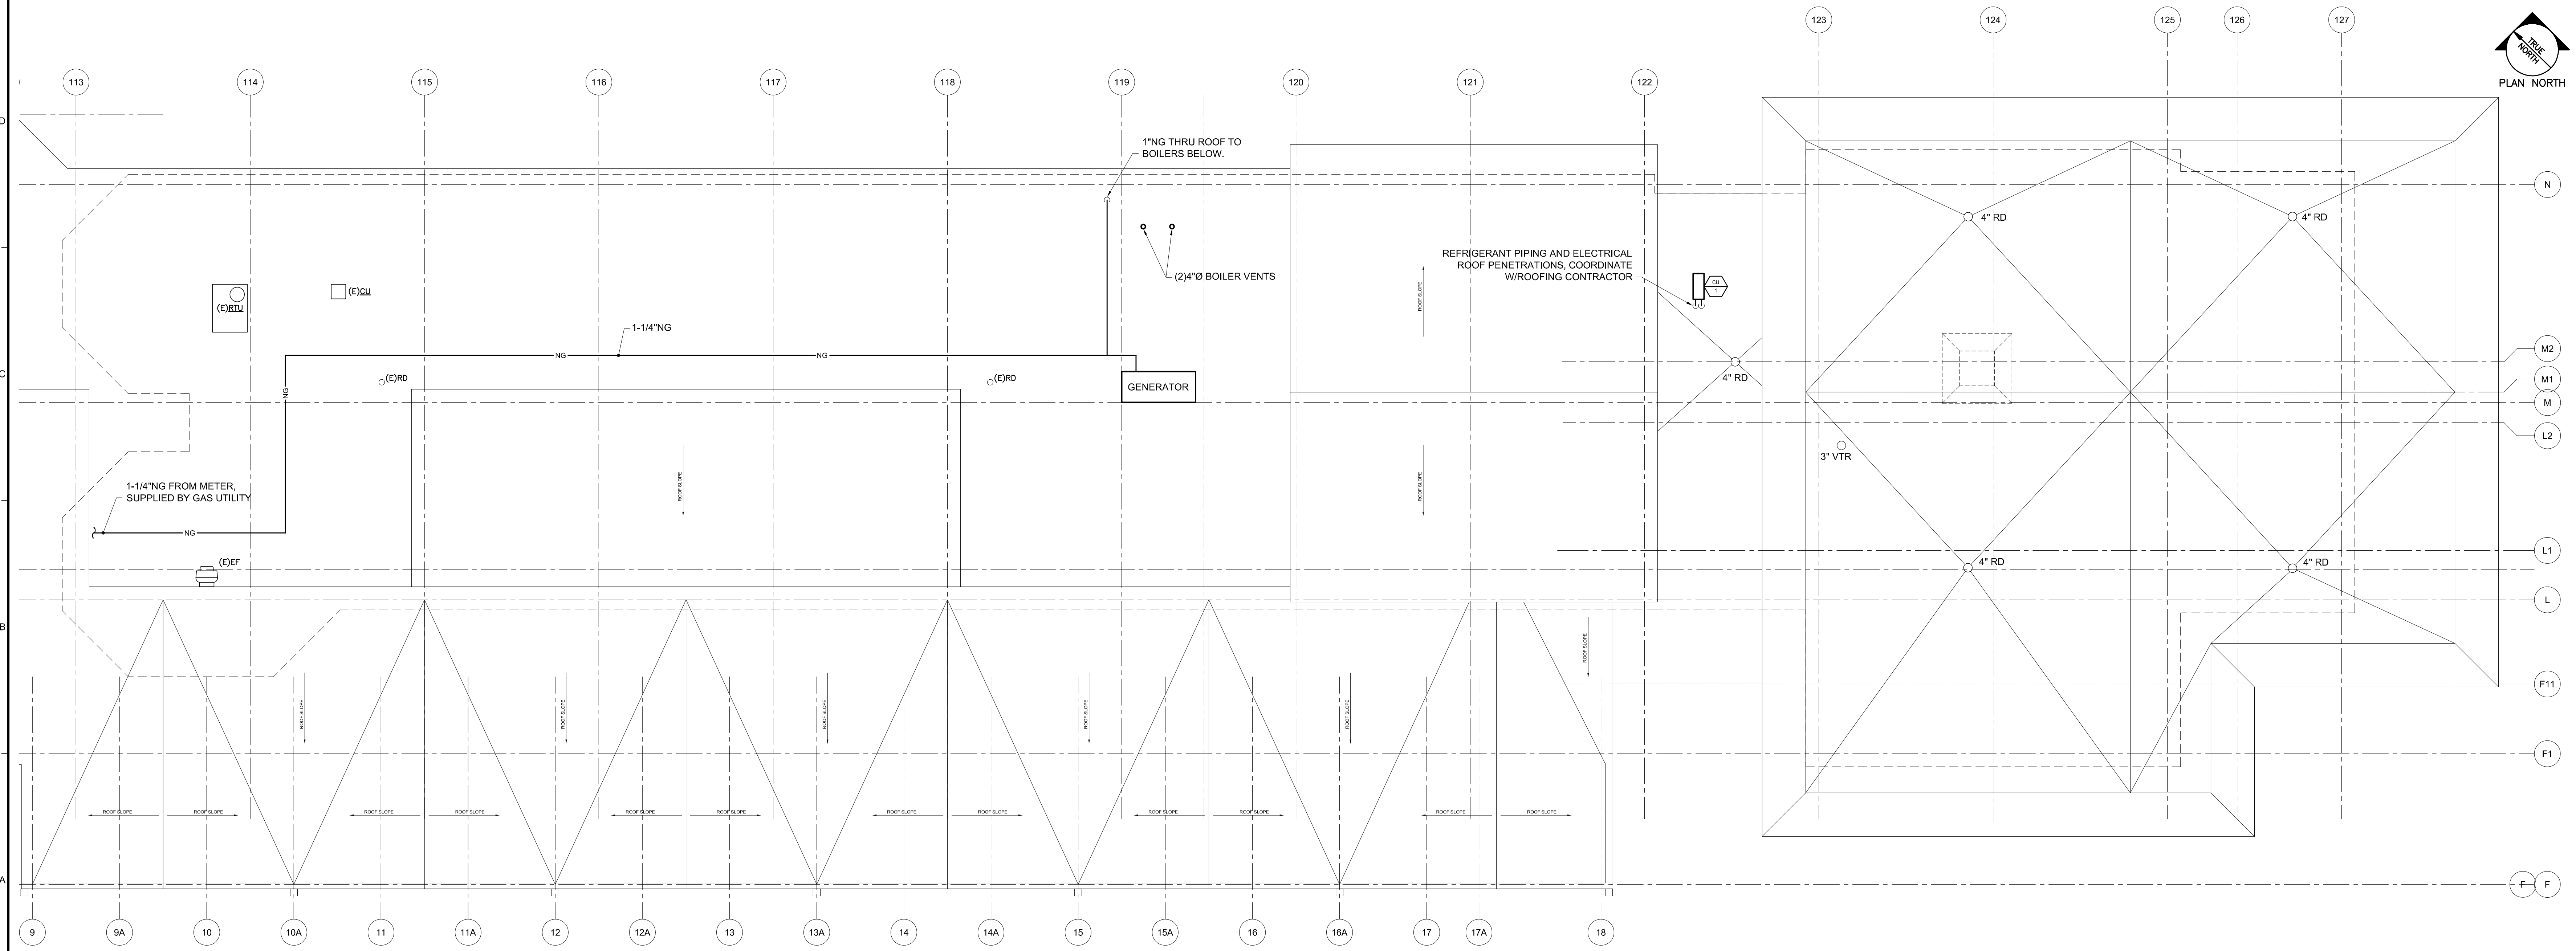

**A1 MECHANICAL PLAN ~ ROOF**  
 1/8" = 1'-0"

**Allied Engineering**  
 Structural Mechanical  
 Electrical Commissioning

**160 Veranda Street  
 Portland, Maine 04103**  
 T: 207.221.2260  
 F: 207.221.2266  
 Web: www.allied-eng.com

Allied Project No: 12008  
 Cad File: 12008M.dwg  
 Checked By: IAM

**SSA**

Scott Simons Architects  
 75 York Street, Portland, Maine 04101  
 www.simonsarchitects.com  
 207.772.4656

PROJECT NAME:  
**CASCO BAY FERRY TERMINAL**

RENOVATIONS & ADDITIONS  
 56 COMMERCIAL STREET  
 PORTLAND, MAINE 04101

SEAL:

STATE OF MAINE  
 IAN A. MACDONALD  
 No. 6990  
 LICENSED PROFESSIONAL ENGINEER

THIS DRAWING IS THE PROPERTY OF SCOTT SIMONS ARCHITECTS (SSA) AND IS NOT TO BE COPIED OR REPRODUCED IN PART OR WHOLE. ©2012 SCOTT SIMONS ARCHITECTS, LLC

REVISION:	DATE
1	DATE
2	DATE
3	DATE
4	DATE
5	DATE
6	DATE

DATE OF ISSUE: MAY 14, 2013  
 PROJECT NUMBER: 2011-0270  
 STATUS: ISSUED FOR BIDDING

**MECHANICAL PLANS ~ ROOF**

**MH-102**

2008 © Scott Simons Architects LLC

N:\Projects\2012\12008 - Casco Bay Ferry Terminal\00 Drawing Files\12008M.dwg May 13, 2013 8:17am