


PROJ. MANAGER	PAUL POTTLE	DATE	
DESIGN-DETAILED		SIGNATURE	
CHECKED-REVIEWED		P. LICENSE NUMBER	ARC 2644
DESIGN-DETAILED2		DATE	10/08/2004
DESIGN-DETAILED3		REVISIONS 1	
REVISIONS 1		REVISIONS 2	
REVISIONS 2		REVISIONS 3	
REVISIONS 3		REVISIONS 4	
REVISIONS 4		FIELD CHANGES	

CITY OF PORTLAND
 OCEAN GATEWAY PHASE 1
 GROUND FLOOR REFLECTED CEILING

A700-R

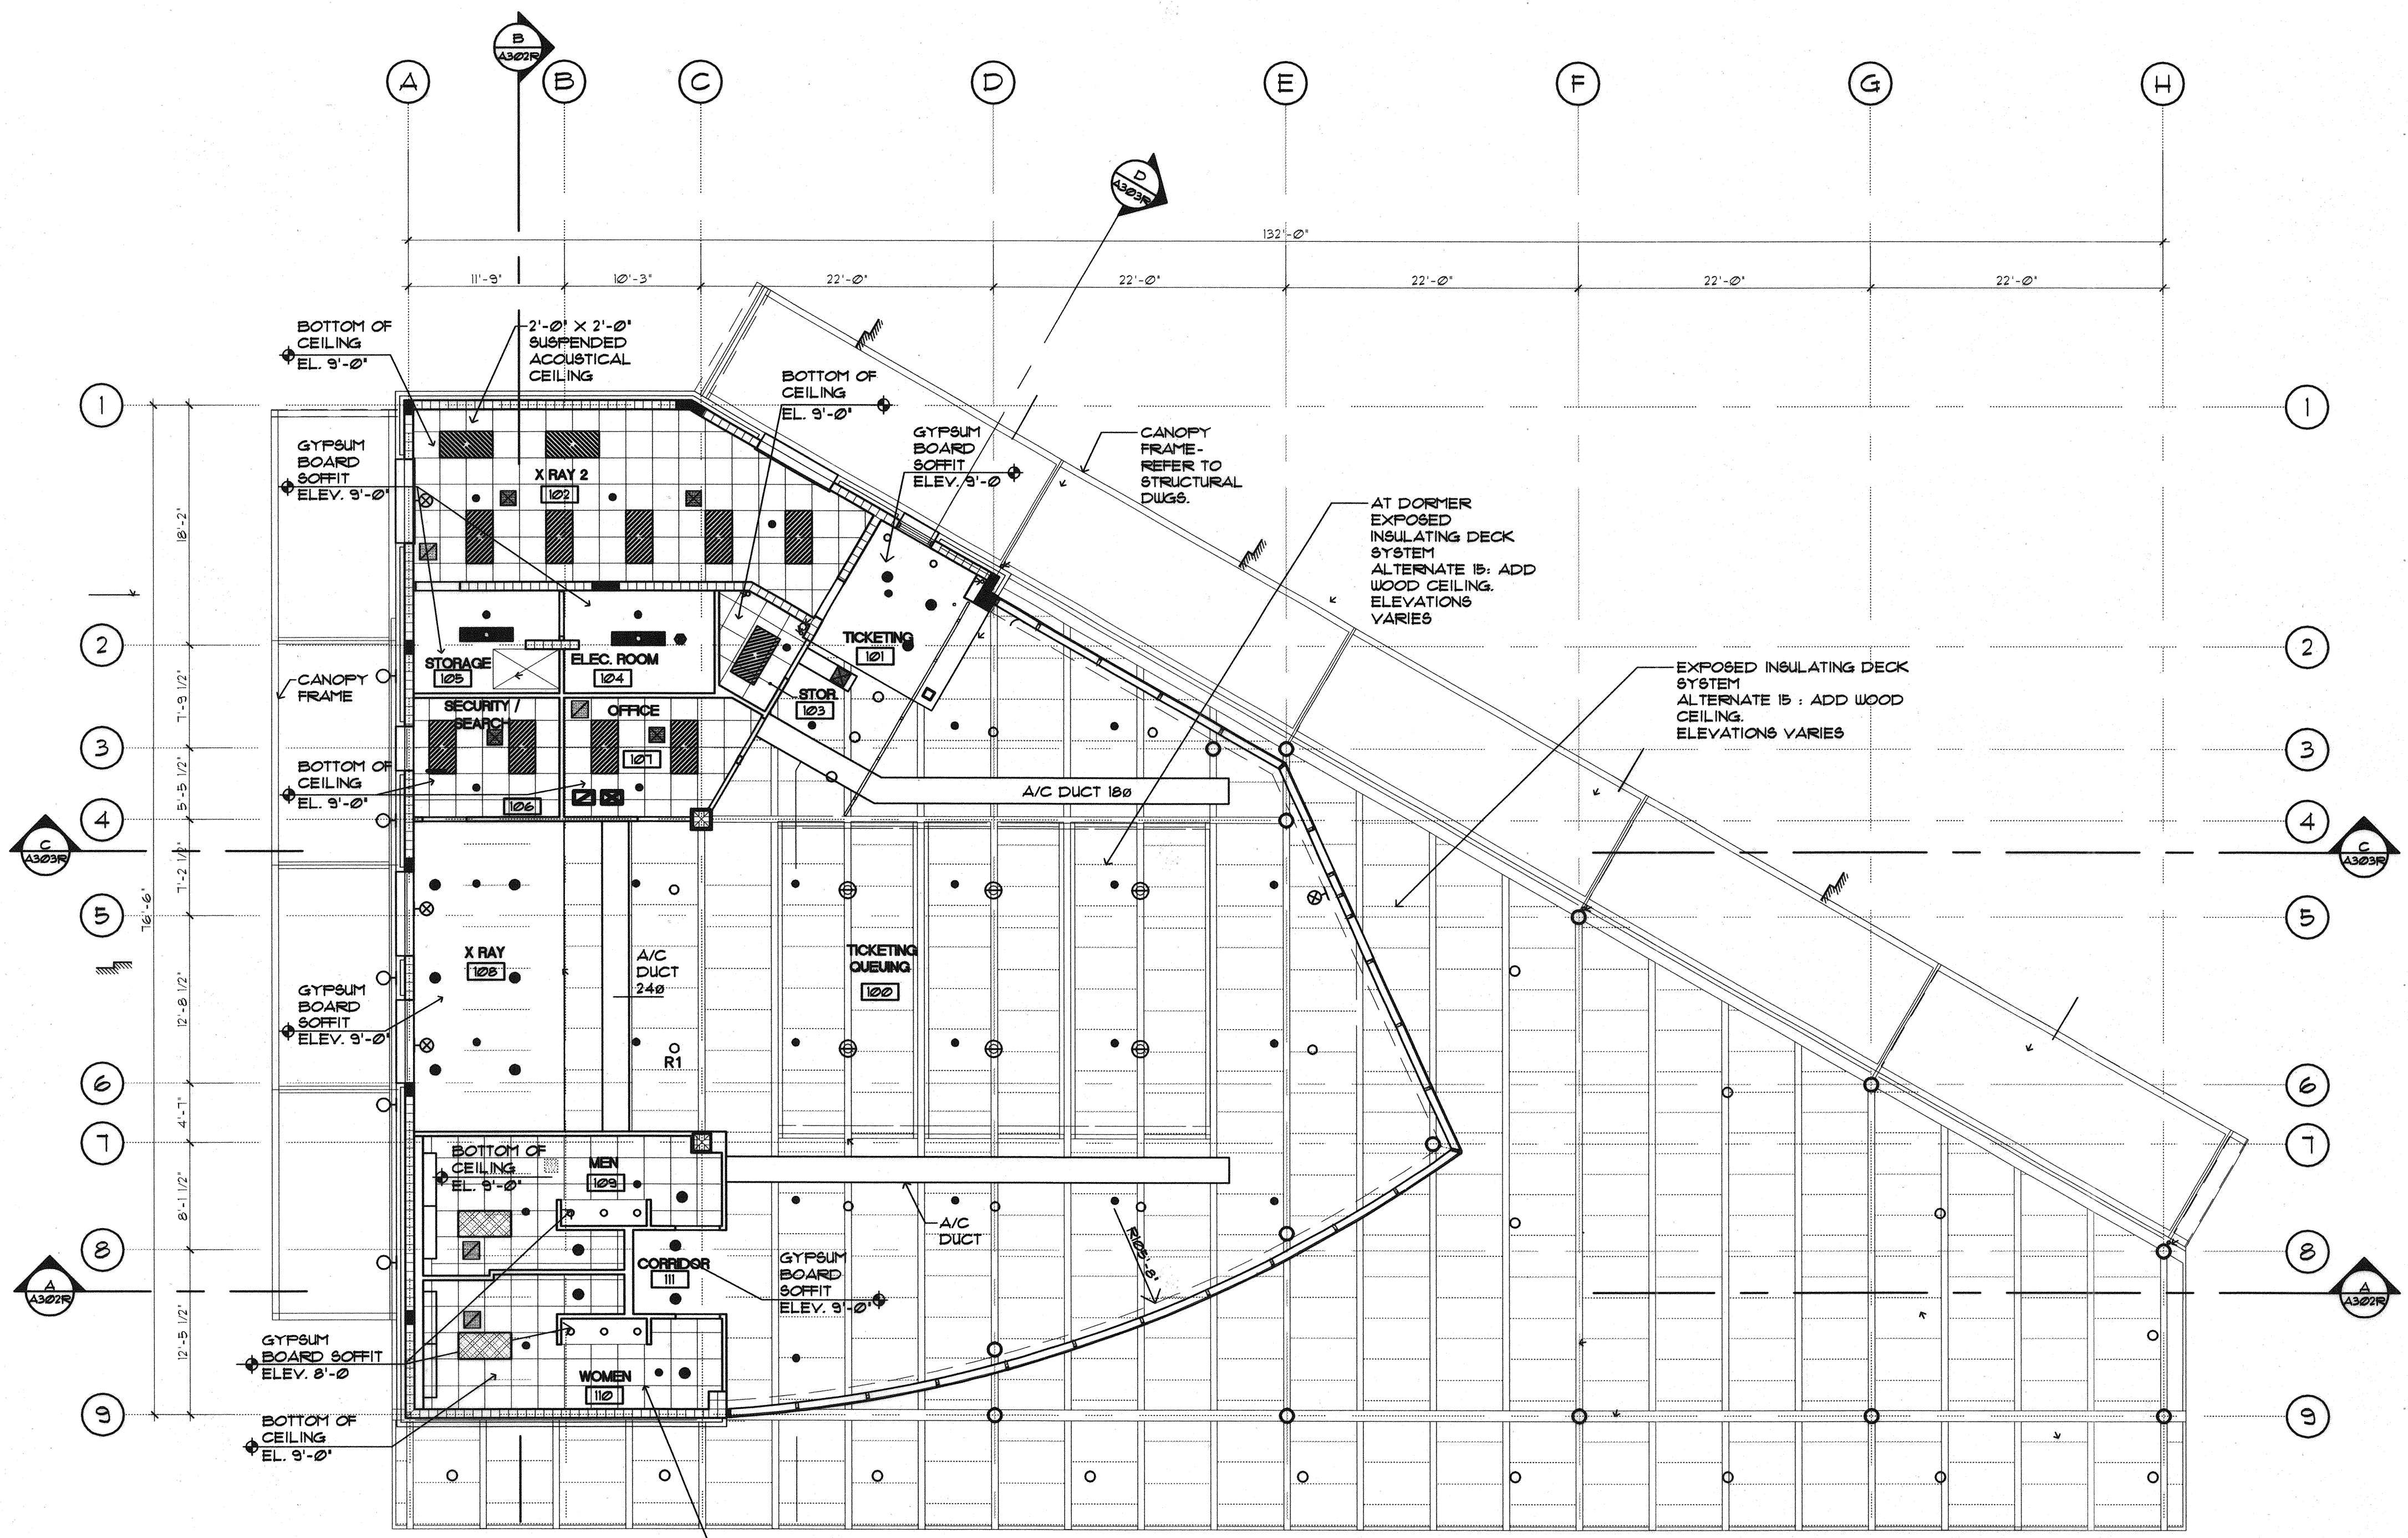

REFLECTED CEILING
 GROUND FLOOR PLAN
 SCALE: 1/8" = 1'-0"

FIXTURE LEGEND	
	A1 RECESSED 2 x 4 FLUORESCENT TROFFER WITH GRID CEILING FRAME
	A2 RECESSED 1 x 4 STATIC FLUORESCENT TROFFER WITH FLUSH FRAM FOR SUSPENDED GRID CEILING, A 1/2" SQUARE WHITE EGGRATE LOVER, AND ELECTRONIC, LOW HARMONIC BALLASTS.
	R1 8-3/4" DIAMETER PENDANT MOUNTED FIXTURE WITH DIE-CAST ALUMINUM HOUSING
	B1 1-3/8" RECESSED WALL WASH ACCENT FIXTURE DIAMETER OPEN PENDANT MOUNTED FIXTURE WITH 8" DIAMETER OPEN REFLECTOR CONE WITH LOW IRIDESCENT FINISH.
	B2 RECESSED SOENLIGHT WITH 4-1/2" DIAMETER OPEN APERTURE WITH WHITE REGRESSED BAFFLE AND WHITE METAL TRIM RING.
	R4 PENDANT MOUNTED FIXTURE WITH GLASS AND ALUMINUM REFLECTOR
	XVAC DIFFUSER
	YVAC RETURN AIR GRILLE
	J1 SURFACE CEILING FLUORESCENT FIXTURE
	S SMOKE DETECTOR
	X1 WALL MOUNTED EXIT LIGHT FIXTURE
	915 13.2" DIAMETER SEMI-RECESSED CANOPY LIGHT WITH CAST ALUMINUM FIXTURE HOUSING AND IMPACT RESISTANT POLYCARBONATE DOME DIFFUSER.
	920 WALL MOUNTED BRACKET CANOPY LIGHT WITH CAST ALUMINUM FIXTURE HOUSING AND GUARD, AND BOROSILICATE GLASS DOME DIFFUSER.