
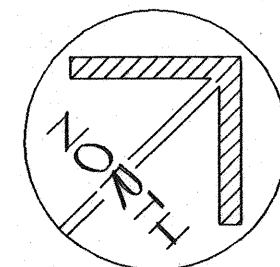


Filename:

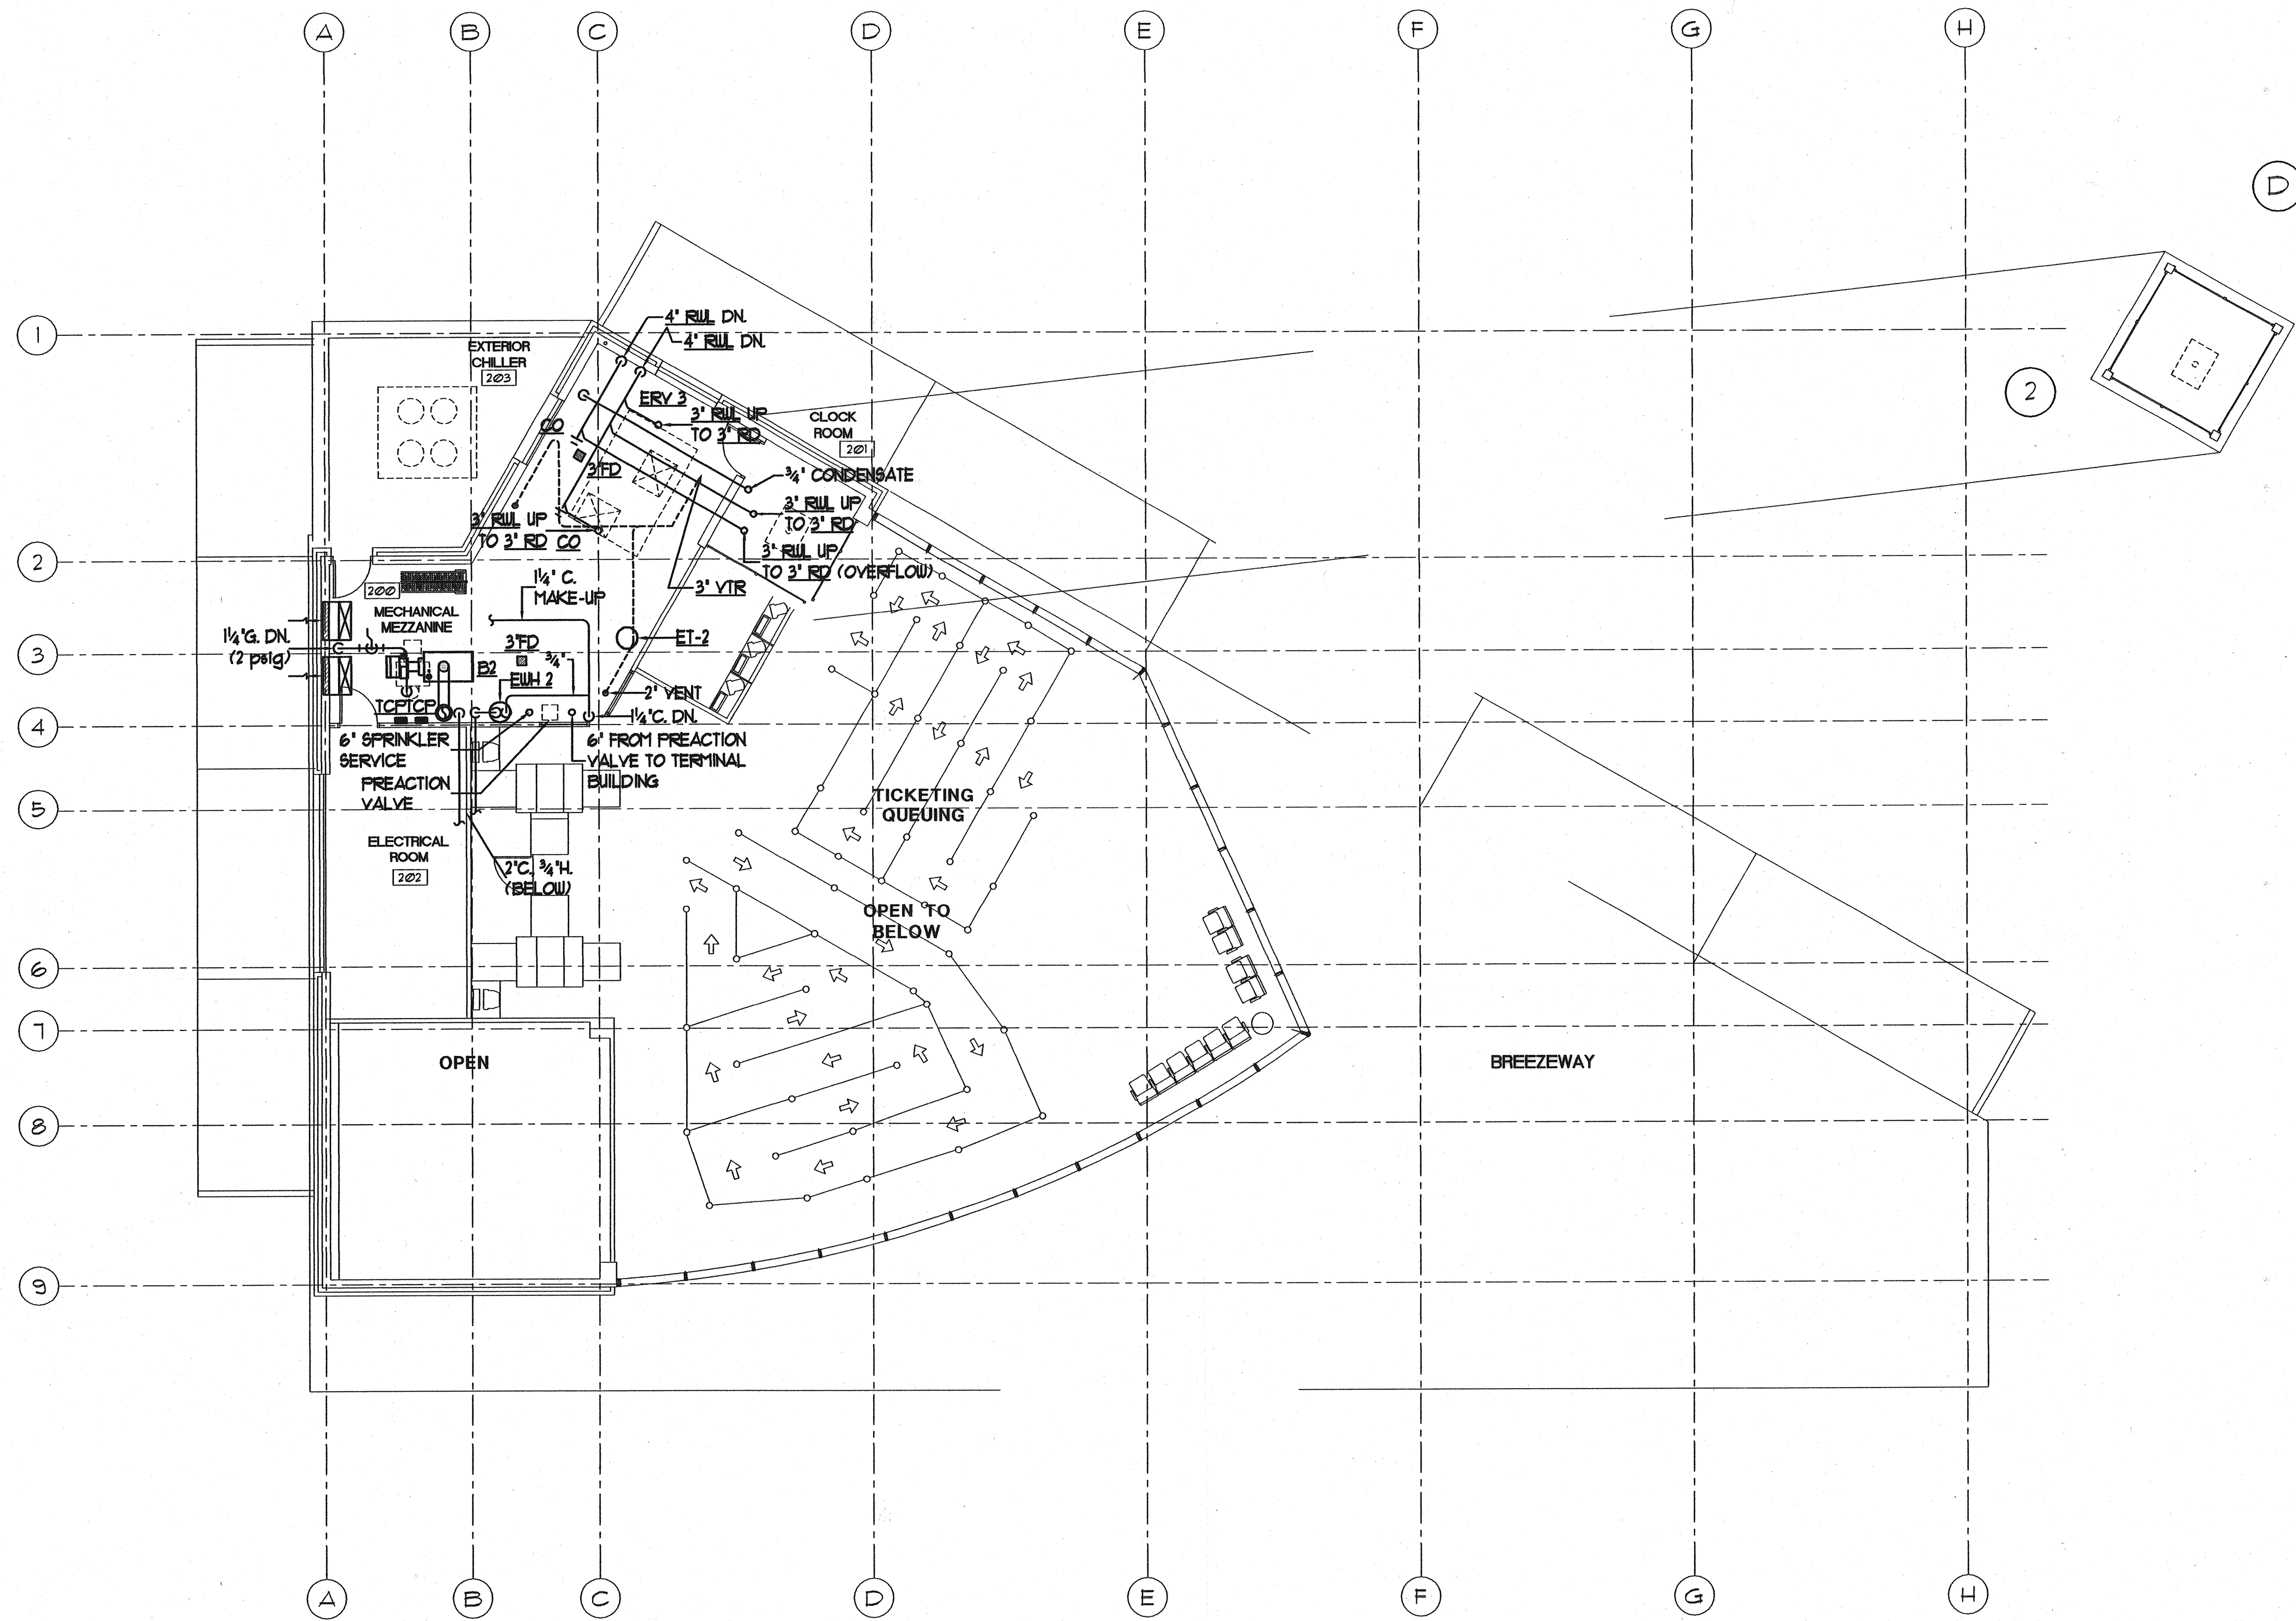


RECEIVING STATION GROUND FLOOR PLAN
SCALE: 1/8"=1'-0"

BENNETT ENGINEERING
CONSULTING ENGINEERS

7 Bennett Road
P.O. Box 297
Portland, ME 04106
Tel: (207) 865-8475
Fax: (207) 865-1800
office@bennettengineering.com

STATE OF MAINE
DEPARTMENT OF TRANSPORTATION
PROJECT NUMBER 009215.00
PIN 009215.00

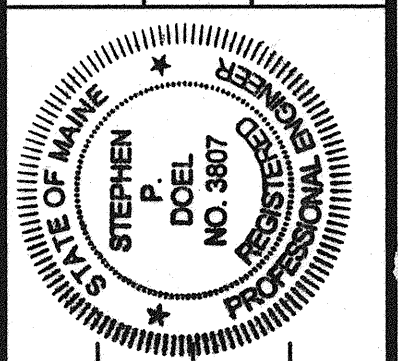

Stephen P. Doel
SIGNATURE
3807
P.E. NUMBER
10/15/04
DATE

PROJ. MGR	MANAGER	PAUL POTTLE	BY	DATE
DESIGN-DETAILED	SMR	SMR	SP DOEL	10/05/04
CHECKED-REVIEWED	SMR	SMR	SP DOEL	10/05/04
DESIGN-DETAILED	SMR	SMR	SP DOEL	10/05/04
REVISIONS 1				
REVISIONS 2				
REVISIONS 3				
REVISIONS 4				
FIELD CHANGES				

CITY OF PORTLAND
OCEAN GATEWAY PHASE 1
RECEIVING STATION
PLUMBING MEZZANINE PLAN

P101-R