
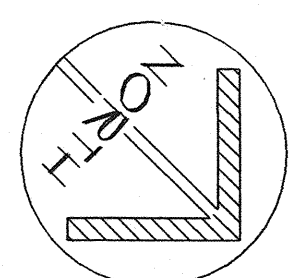


Filename:

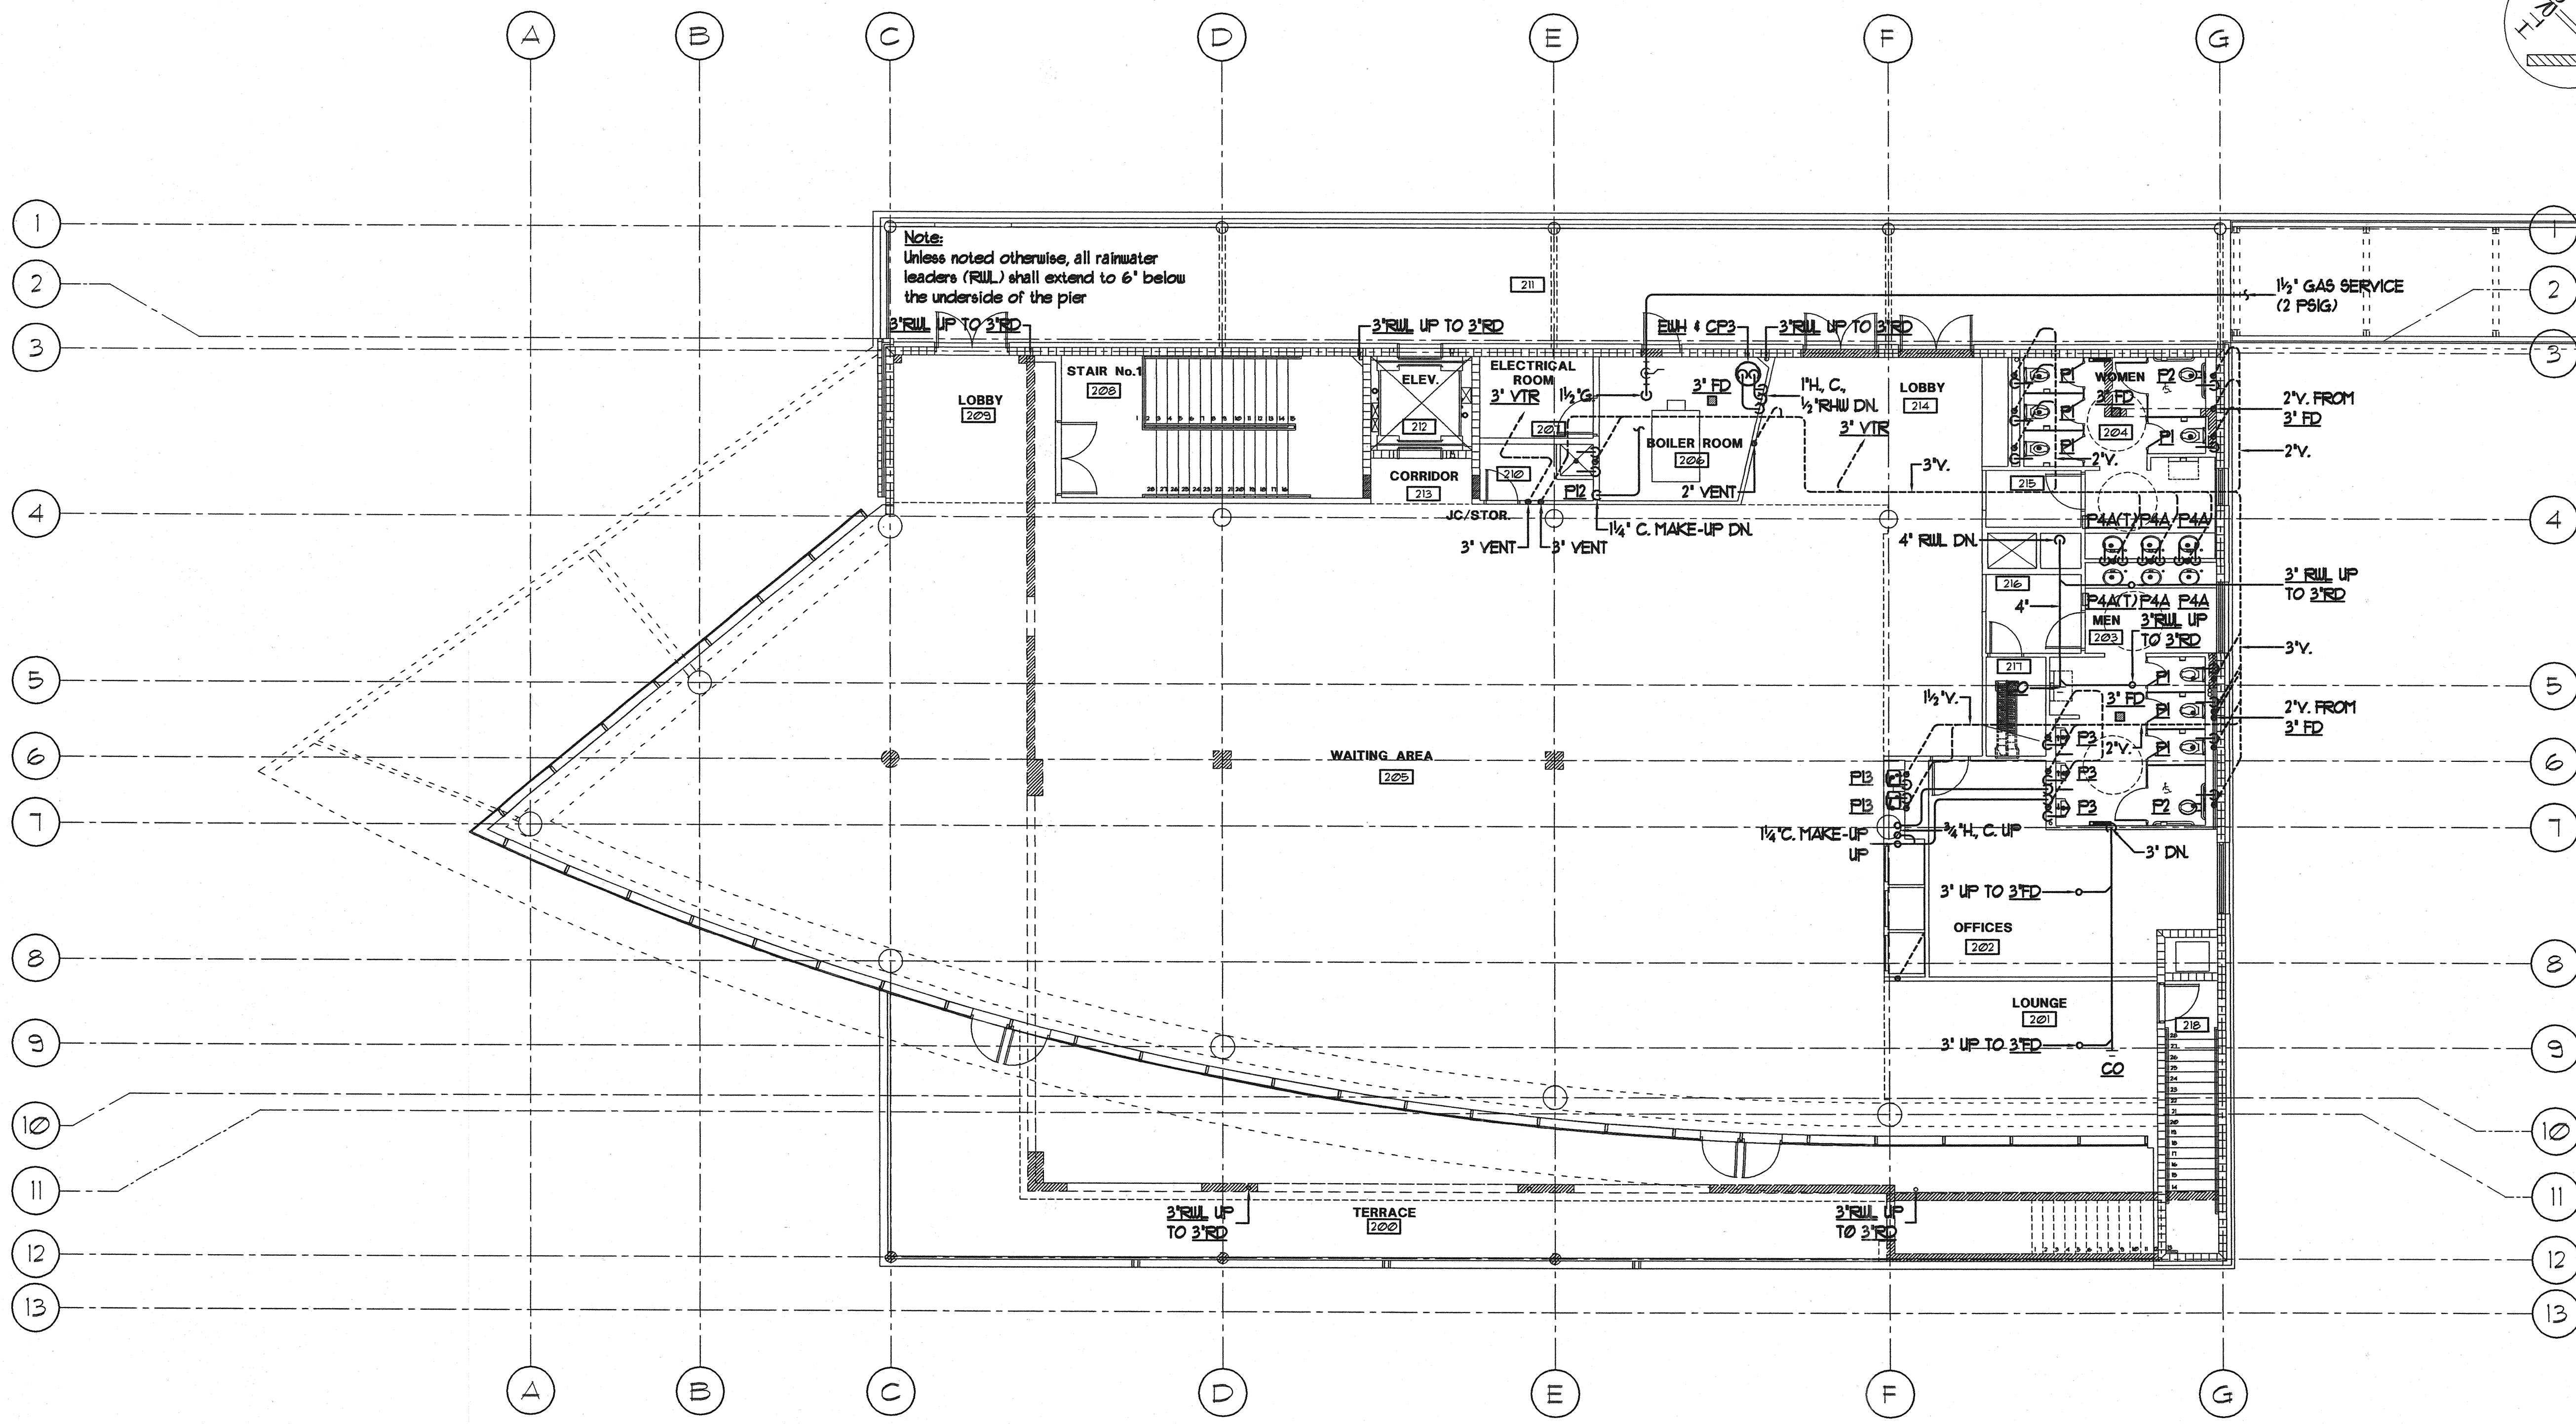

PROF. REGISTERED
STEPHEN P. DOEL
NO. 3807
DATE 10/5/04

PROJ. MGR.	MANAGER	PAUL	POTILE	DATE
DESIGN-DETAILED	SMR	SMR	SMR	10/05/04
CHECKED-REVIEWED	SMR	SMR	SMR	10/05/04
DESIGN-DETAILED	SMR	SMR	SMR	10/05/04
DESIGN-DETAILED	SMR	SMR	SMR	10/05/04
REVISIONS 1				
REVISIONS 2				
REVISIONS 3				
REVISIONS 4				
FIELD CHANGES				

CITY OF PORTLAND
OCEAN GATEWAY PHASE 1
TERMINAL BUILDING
UPPER LEVEL PLUMBING PLAN

TERMINAL BUILDING UPPER LEVEL PLAN
SCALE: 1/8" = 1'-0"

P101-T