


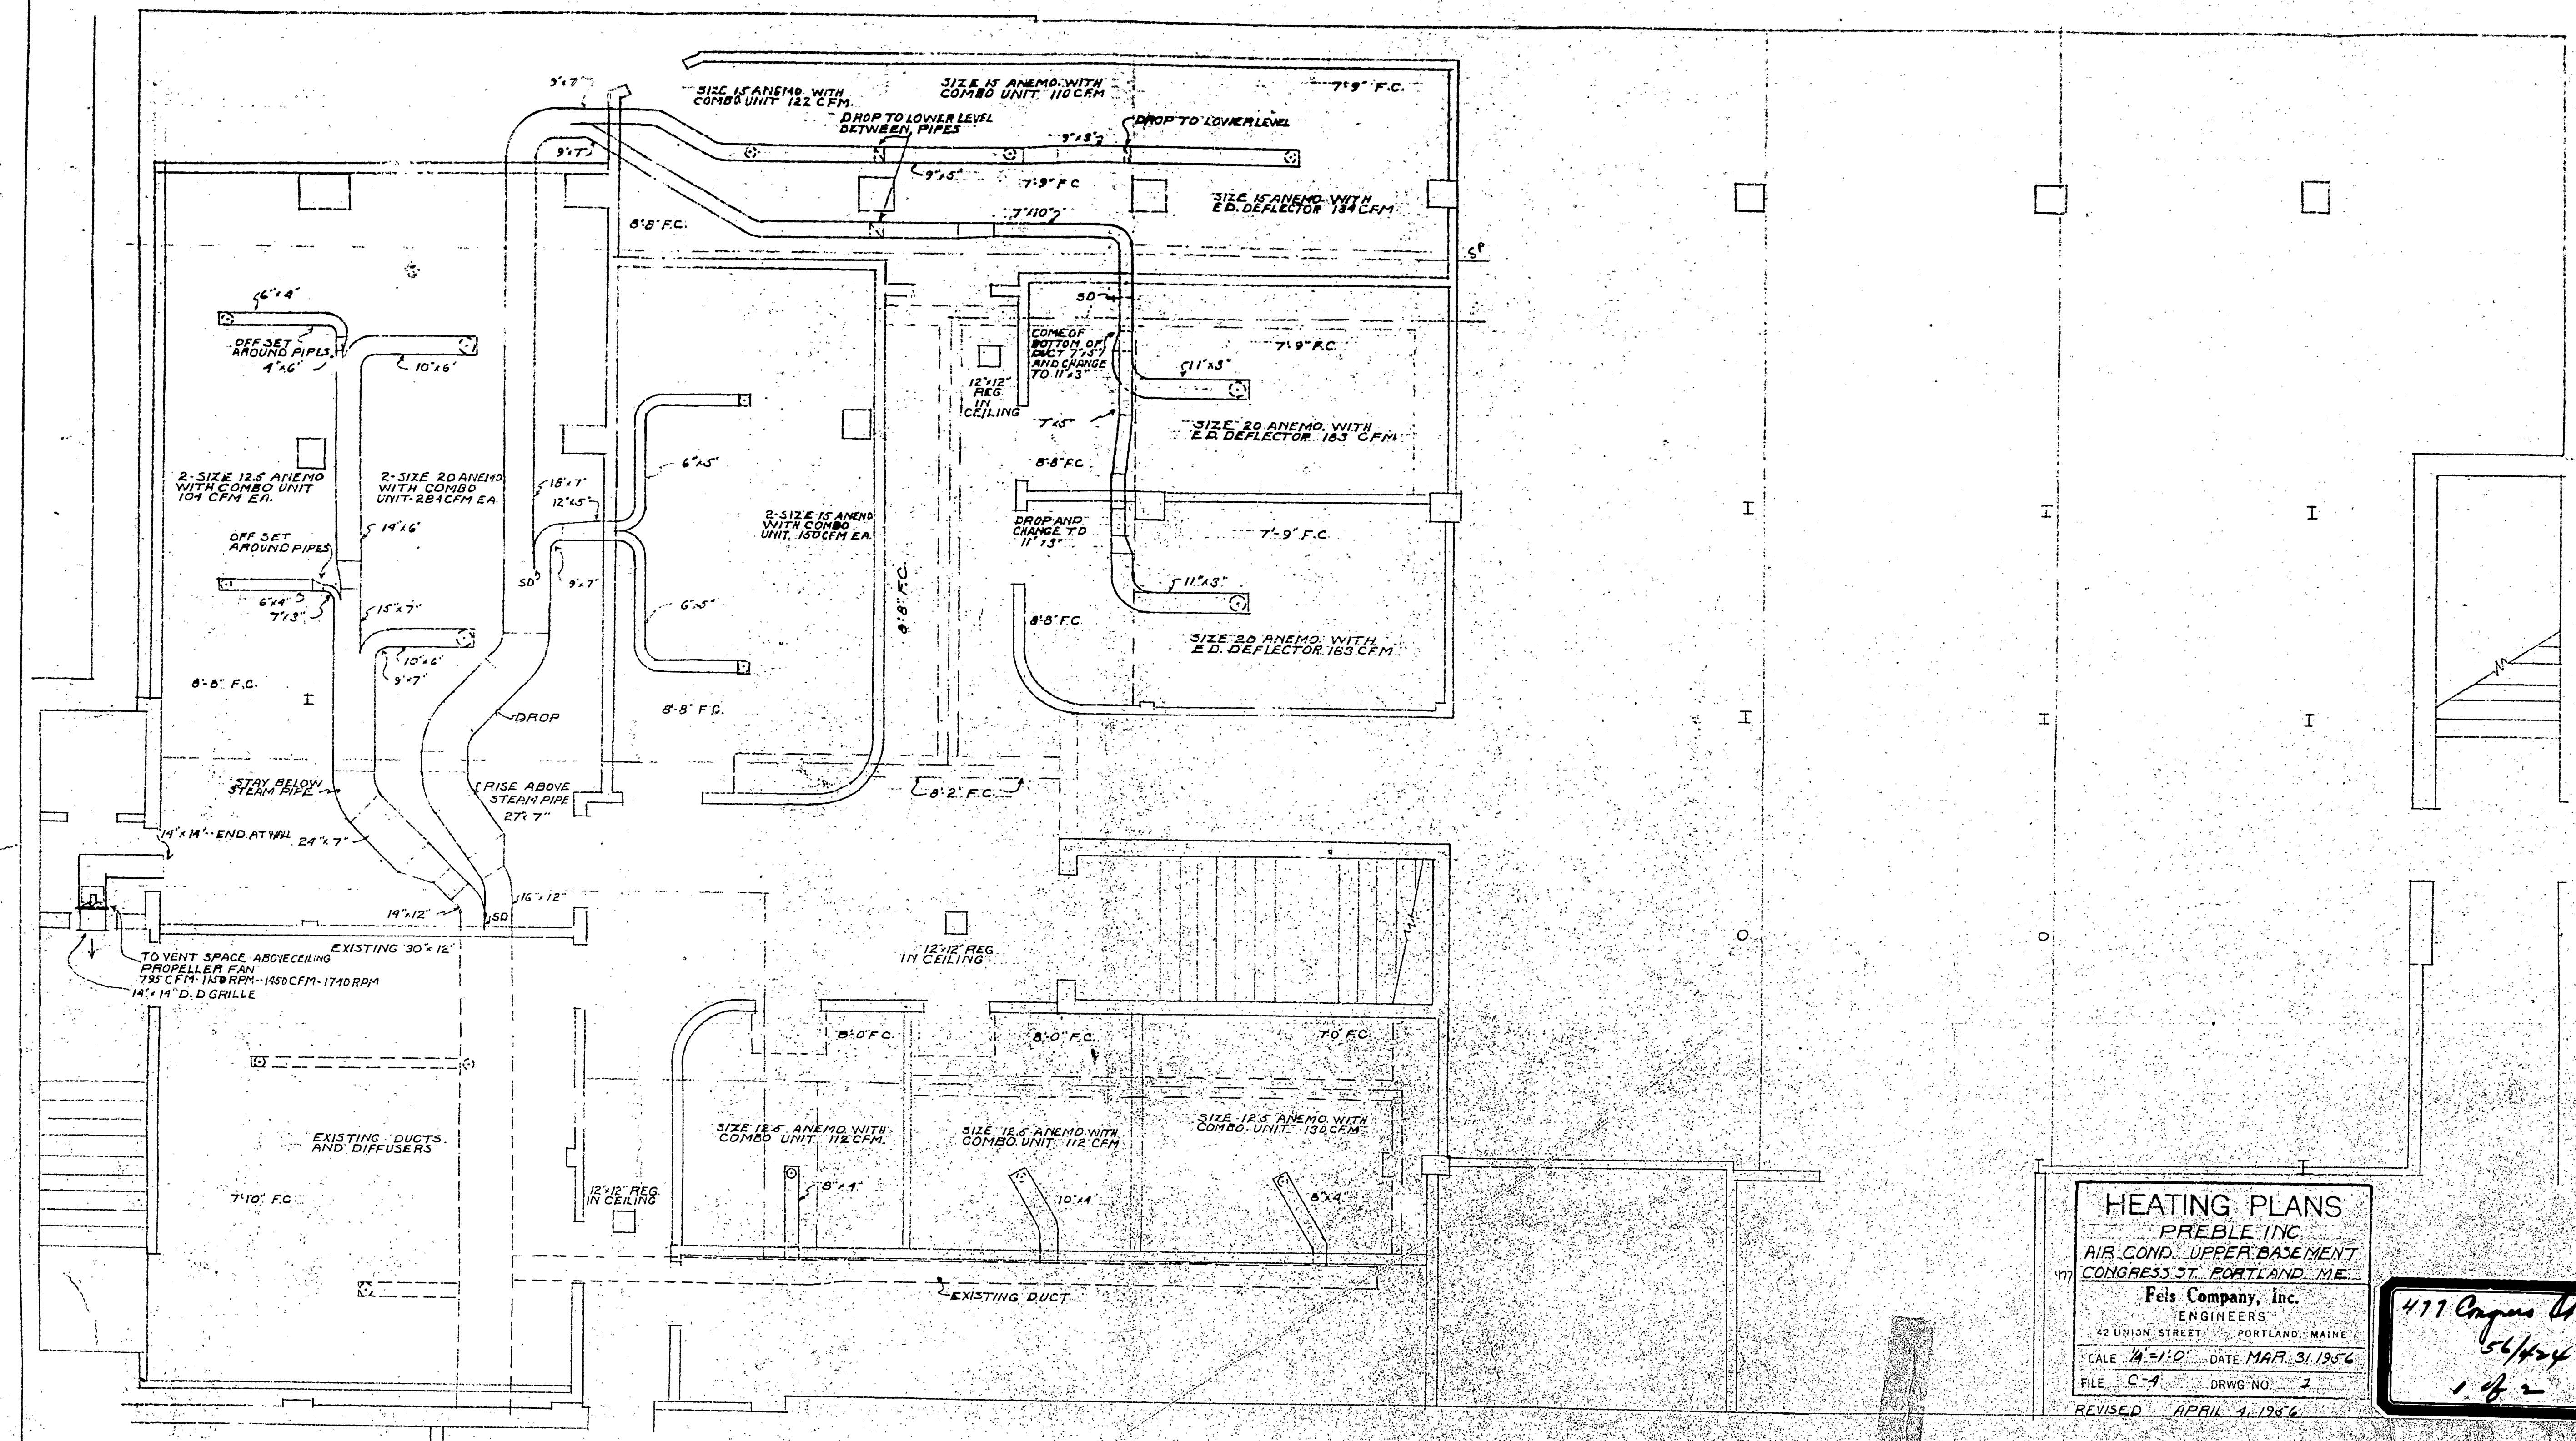

HEATING PLANS
PREBLE INC.
AIR COND. UPPER BASEMENT
CONGRESS ST. PORTLAND, ME.
Fels Company, Inc.
ENGINEERS
42 UNION STREET PORTLAND, MAINE
SCALE 1/4"=1'-0" DATE MAR. 31, 1956
FILE C-4 DRWG NO. 2
REVISED APRIL 4, 1956

477 Angus St.
5/4/54
1 of 2

